
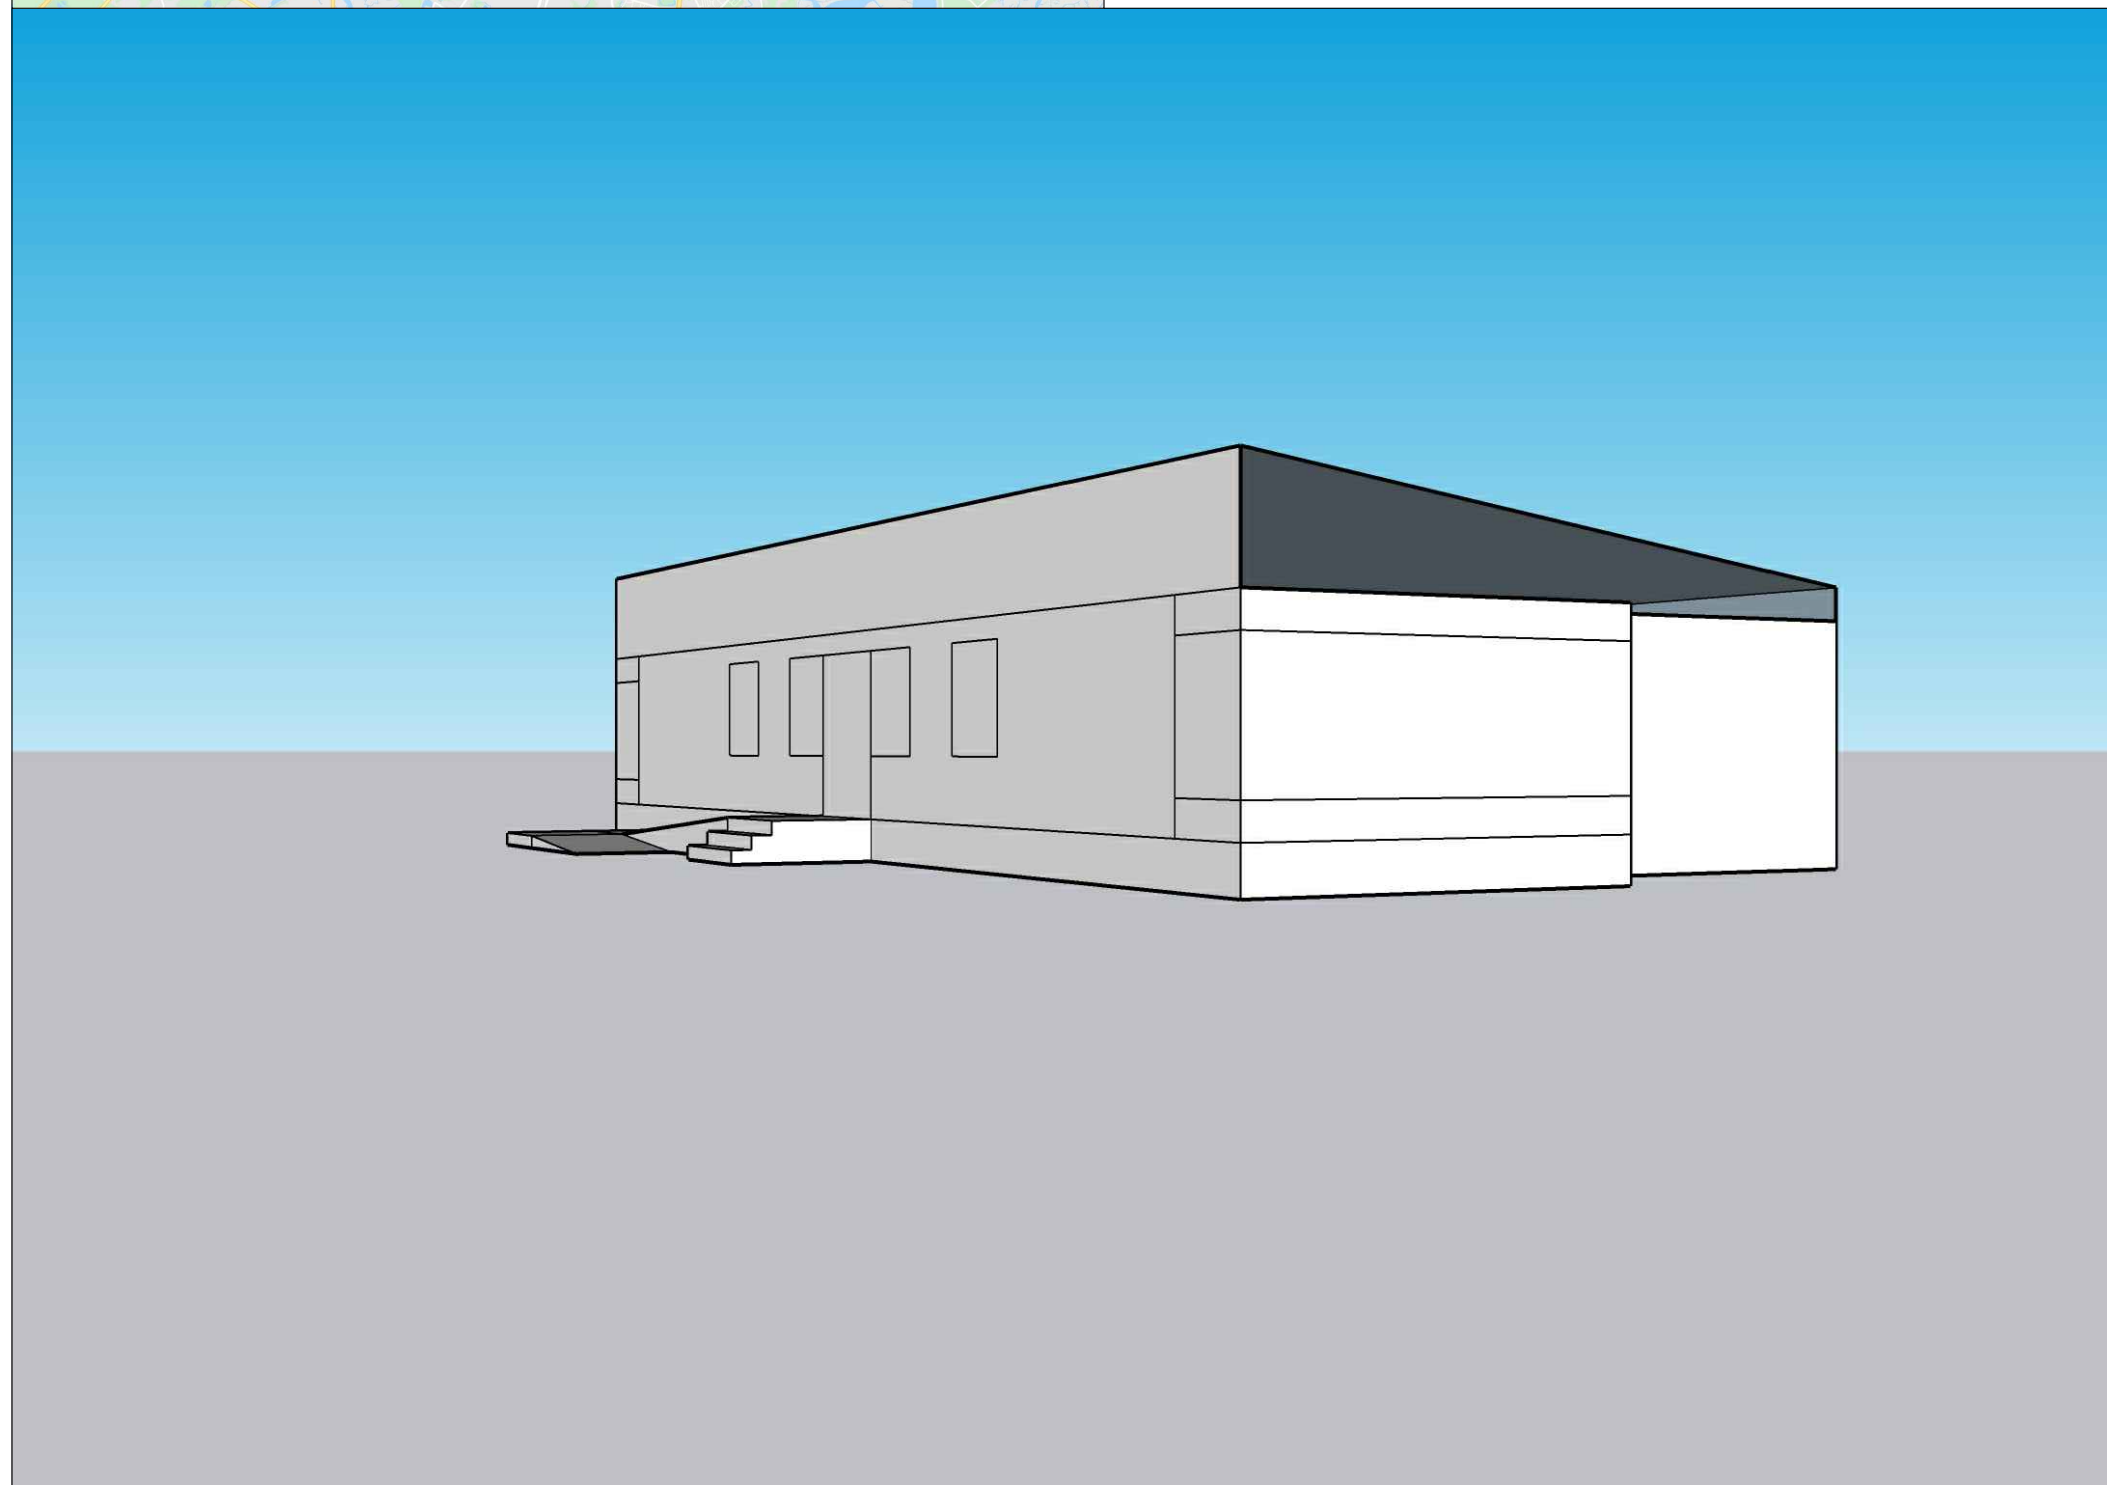
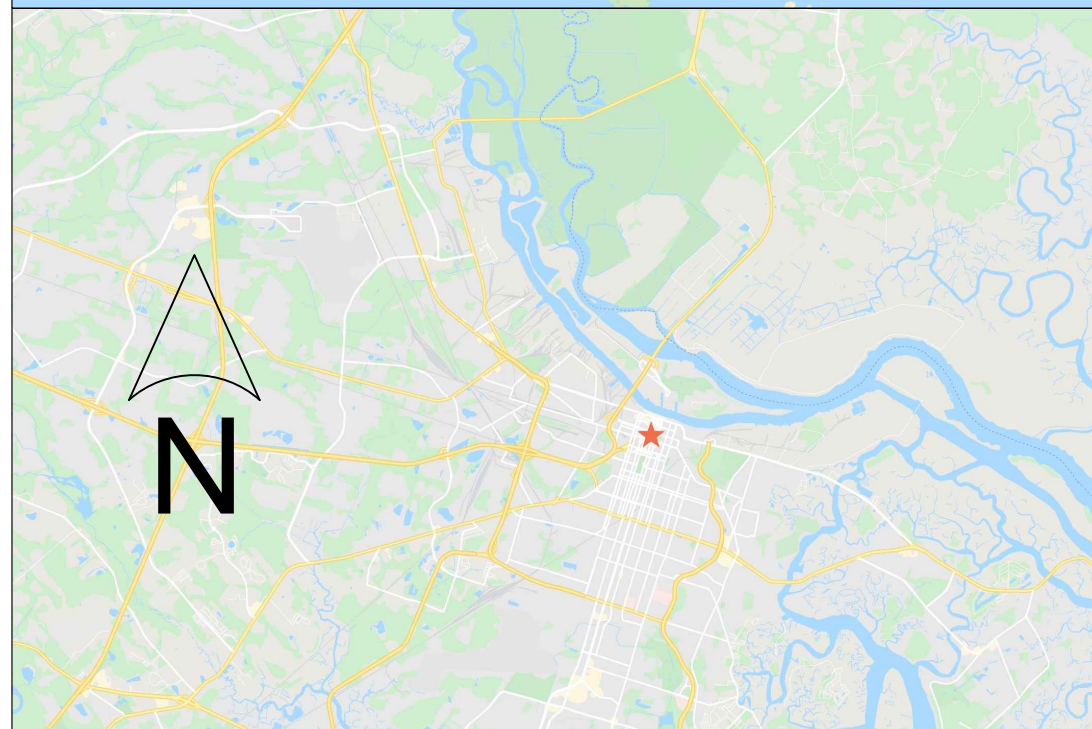


## Project Information

This is a plan for a studio and apartment as part of a rural art camp for high school-level students. A graduate art student who is a weaver lives, works, and teaches at the project location.

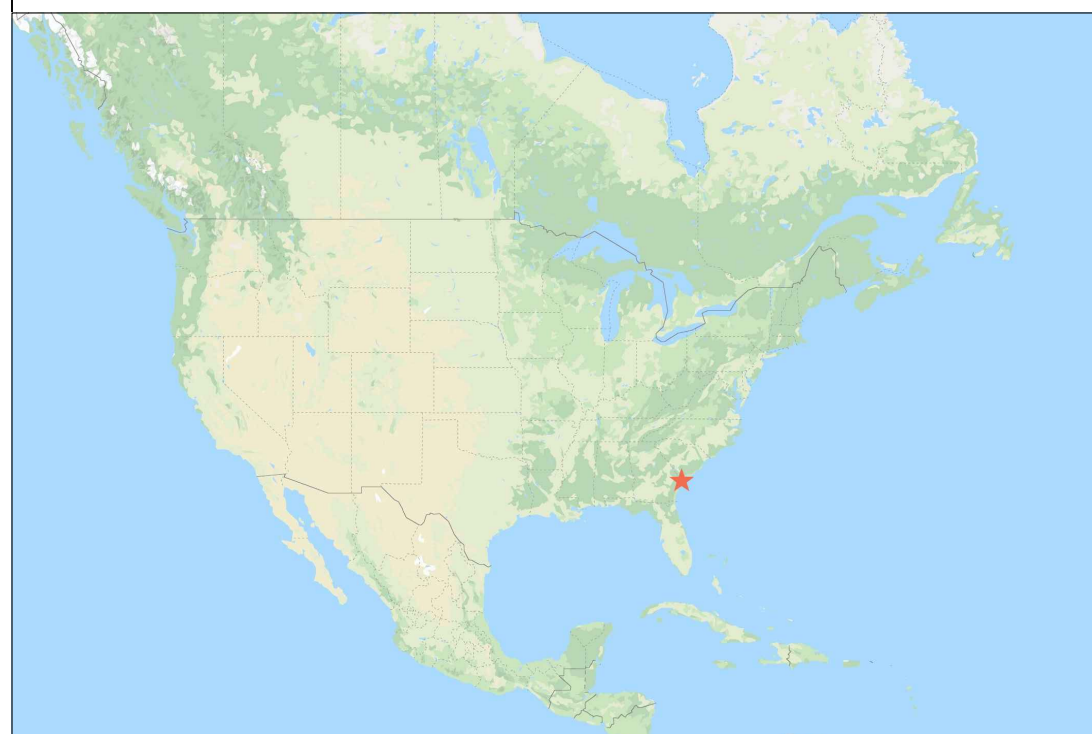

## General Symbols Legend

	Elevation
	Section
	Detail Callout
	Height Marker
	Floor/Ceiling Tags
	Wall Tags
	Object Tags

## Abbreviations

AFF	At Finished Floor
GFCI	Ground Fault Circuit Interrupter
ADA	Americans with Disabilities Act
CPET	Common Path of Egress Travel
TD	Travel Distance

## Design Factors

Occupancy Classification	R,E,S
Building Size	2,290.22 sq. ft.
Number of Floors	1 floor
Occupancy Load	26
Year Built	2021

## Sheet Index

G-001	Coversheet
G-002	Live Safety Plan
I-101	Floor Plan
I-111	Building Section
I-201	Power Plan
I-301	Reflected Ceiling Plan
I-401	Finished Plan
I-501	Furniture Plan
I-601	Elevations
I-701	Details
I-901	Finish Legend

## Applicable Codes

International Building Code	2012
International Residential Code	2012
International Plumbing Code	2012
International Mechanical Code	2012
International Fuel Gas Code	2012
International Energy Conservation Code	2009
International Fire Code	2012
National Electric Code	2014
Live Safety Code, NFPA	2012
Standard Swimming Pool Code	1994
ADA Standards for Accessible Design	2010



1234 Main Street  
City, US 00001

**Weaver**



00 Somewhere Savannah, GA 00001

## Revision


#001	JM	24/06/2021
#002	JM	01/07/2021
#003	JM	06/07/2021
#004	JM	13/07/2021

## COVERSHEET

Project Number	#001
Date	24/06/2021
Drawn By	JM
<b>G-001</b>	
No Scale	

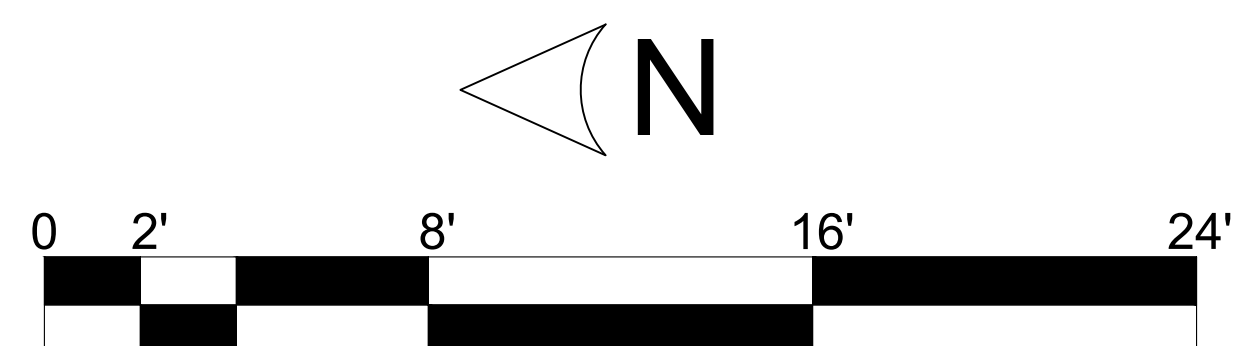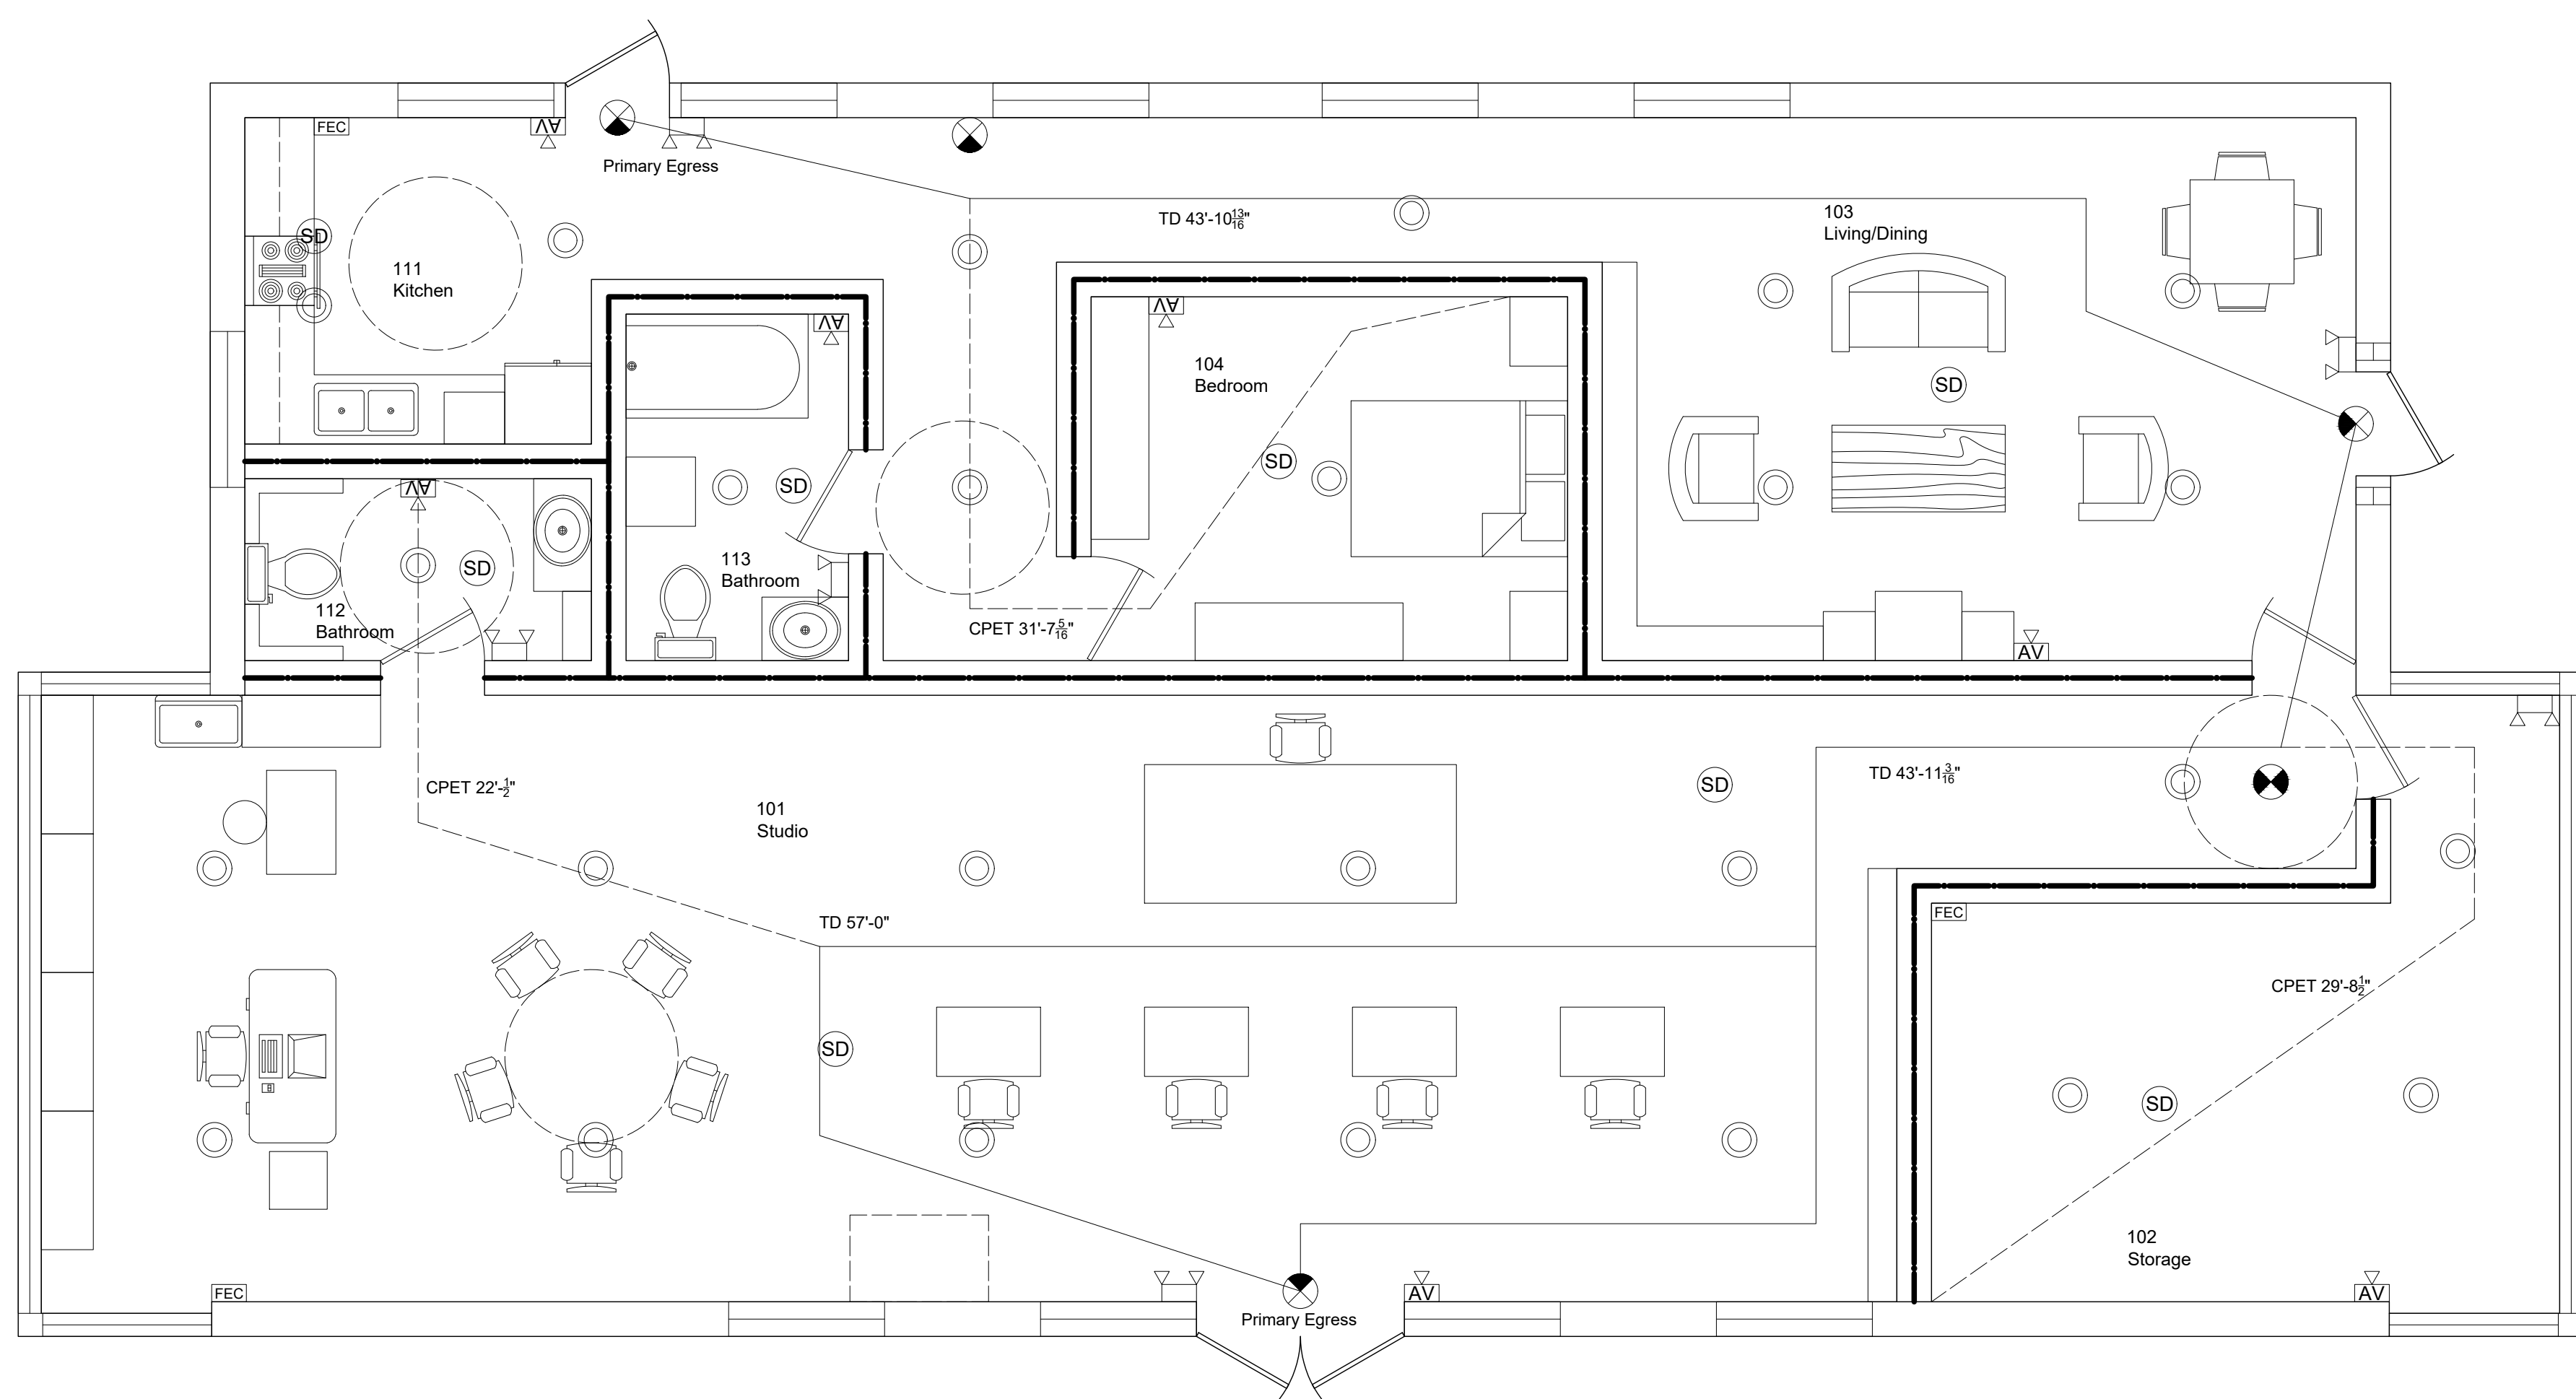

### Half Diagonal Rule

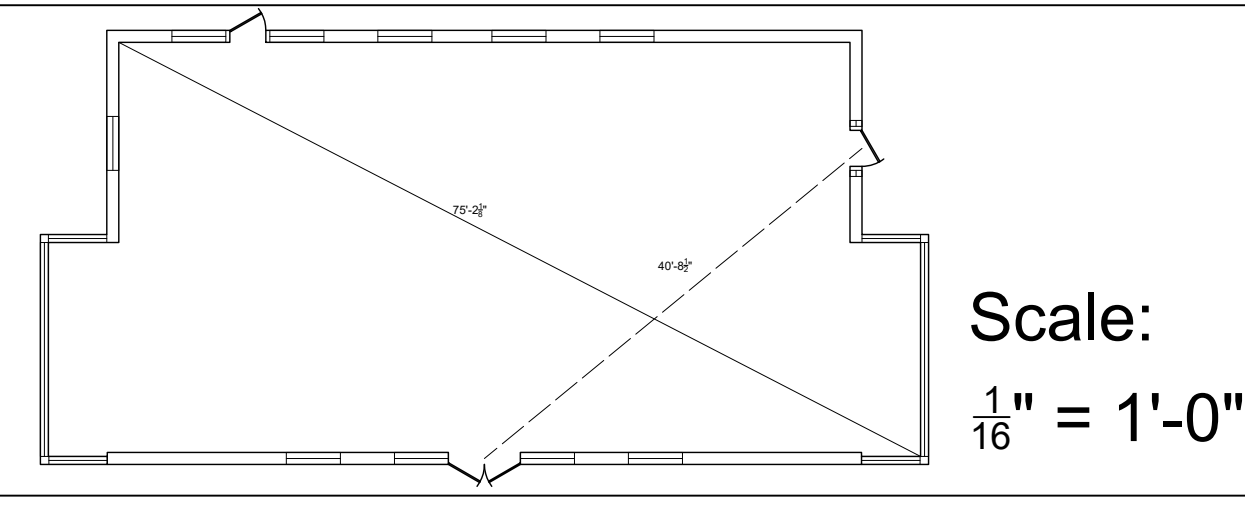

### Life Safety Legend

	Exit Signs
	Emergency Lights
	AV Alarm
	Smoke Detector
	Fire Extinguisher Cabinet
	Sprinkler

### Notes

- 1) All walls are fire rated for 1 hour
- 2) In case of any discrepancy, contact architect



**Weaver**

00 Somewhere Savannah, GA 00001

### Revision

#001	JM	24/06/2021
#002	JM	01/07/2021
#003	JM	06/07/2021
#004	JM	13/07/2021

### Life Safety

Project Number	#001
Date	24/06/2021
Drawn By	JM

**G-002**

1/4" = 1'-0" (unless specified)



1234 Main Street  
City, US 00001

**Weaver**

00 Somewhere Savannah, GA 00001

## Wall Type Legend

**A**


15.9mm (5/8") CertainTeed Type X products, 1 layer, each side of 92mm (35/8") steel studs. CertainTeed's Sustainable Insulation™ 89mm (3 1/2") within cavity.

Fasten boards vertically using 25mm (1") screws spaced 200mm (8") o.c. along edge joints, floor and ceiling tracks, and 300mm (12") o.c in the field. Joints must be offset. Tape and finish joints with CertainTeed products.

**B**

15.9mm (5/8") CertainTeed Type X products, 1 layer, each side of 89mm (3 1/2") 20 ga. load bearing steel studs. CertainTeed's Sustainable Insulation™ 89mm (3 1/2") within cavity.

Fasten boards vertically using 25mm (1") screws spaced 300mm (12") o.c. Joints must be offset. Tape and finish joints with CertainTeed products.

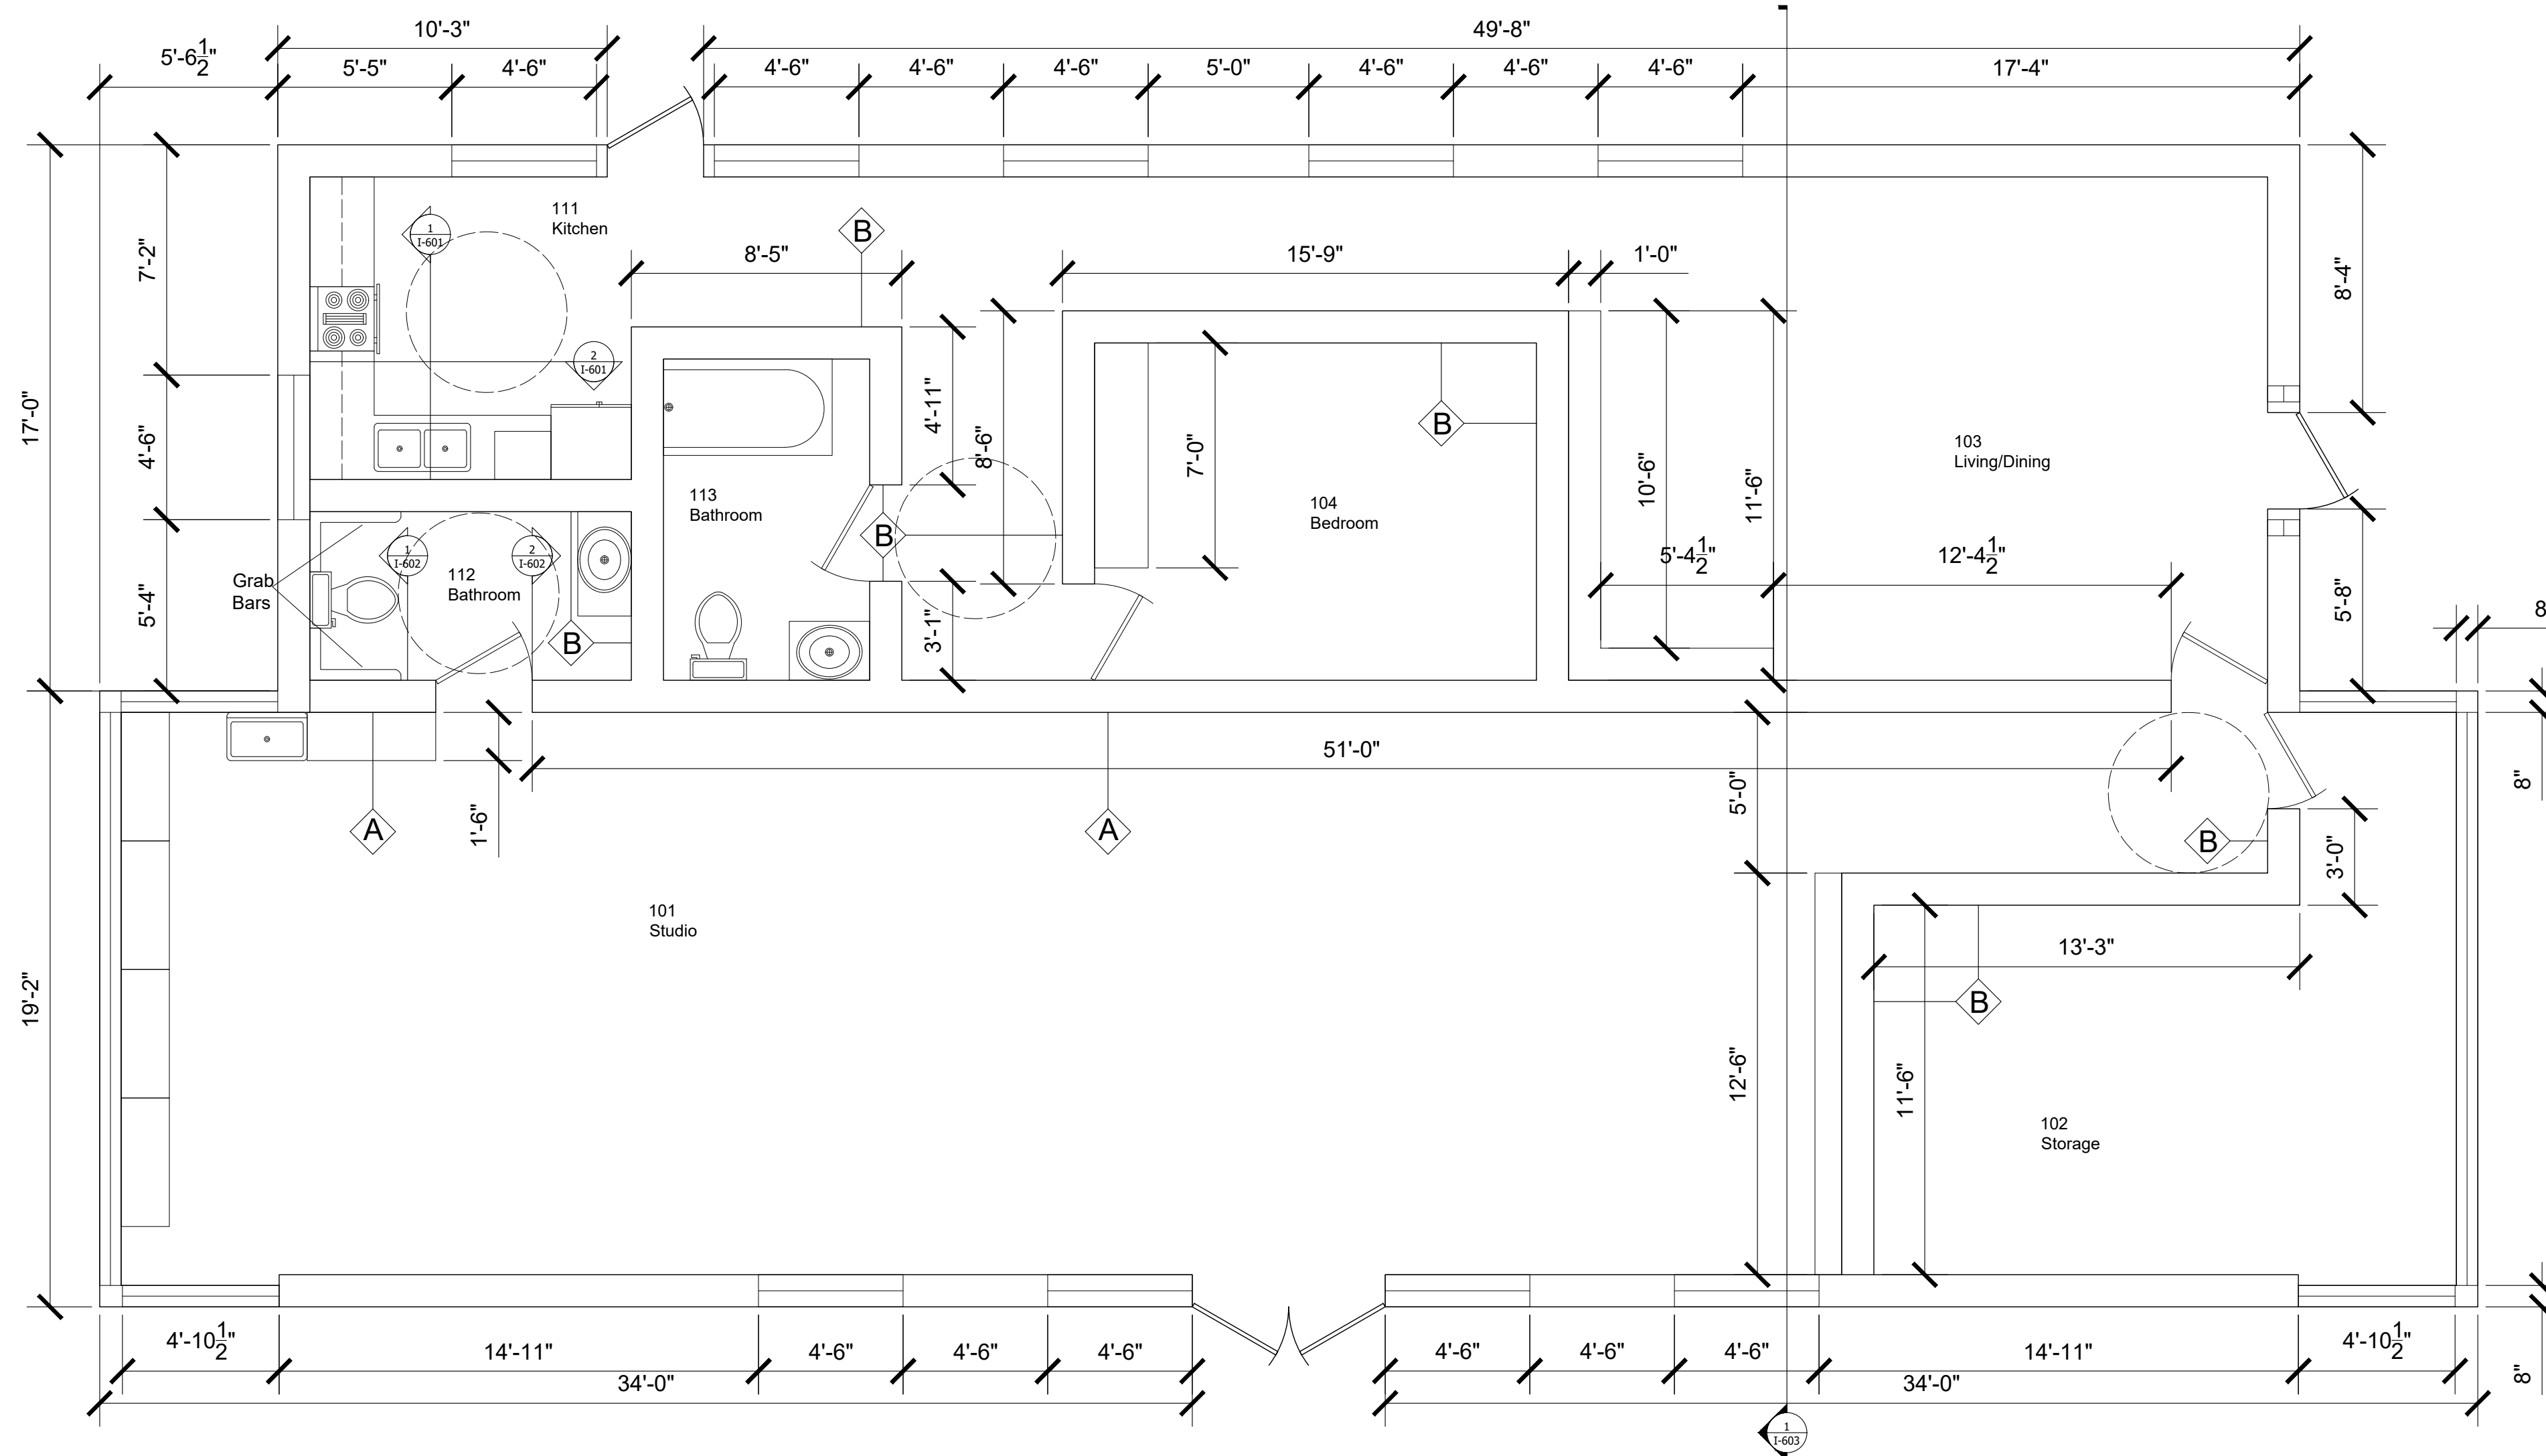

## Notes

- 1) All walls are 12" unless otherwise specified
- 2) In case of any discrepancy, contact architect

## Revision


#	By	Date
#001	JM	24/06/2021
#002	JM	01/07/2021
#003	JM	06/07/2021
#004	JM	13/07/2021

## Floor Plan

Project Number	#001
Date	24/06/2021
Drawn By	JM

**I-101**

1/4" = 1'-0"

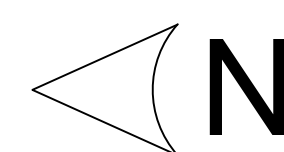






1234 Main Street  
City, US 00001

Weaver

00 Somewhere Savannah, GA 00001

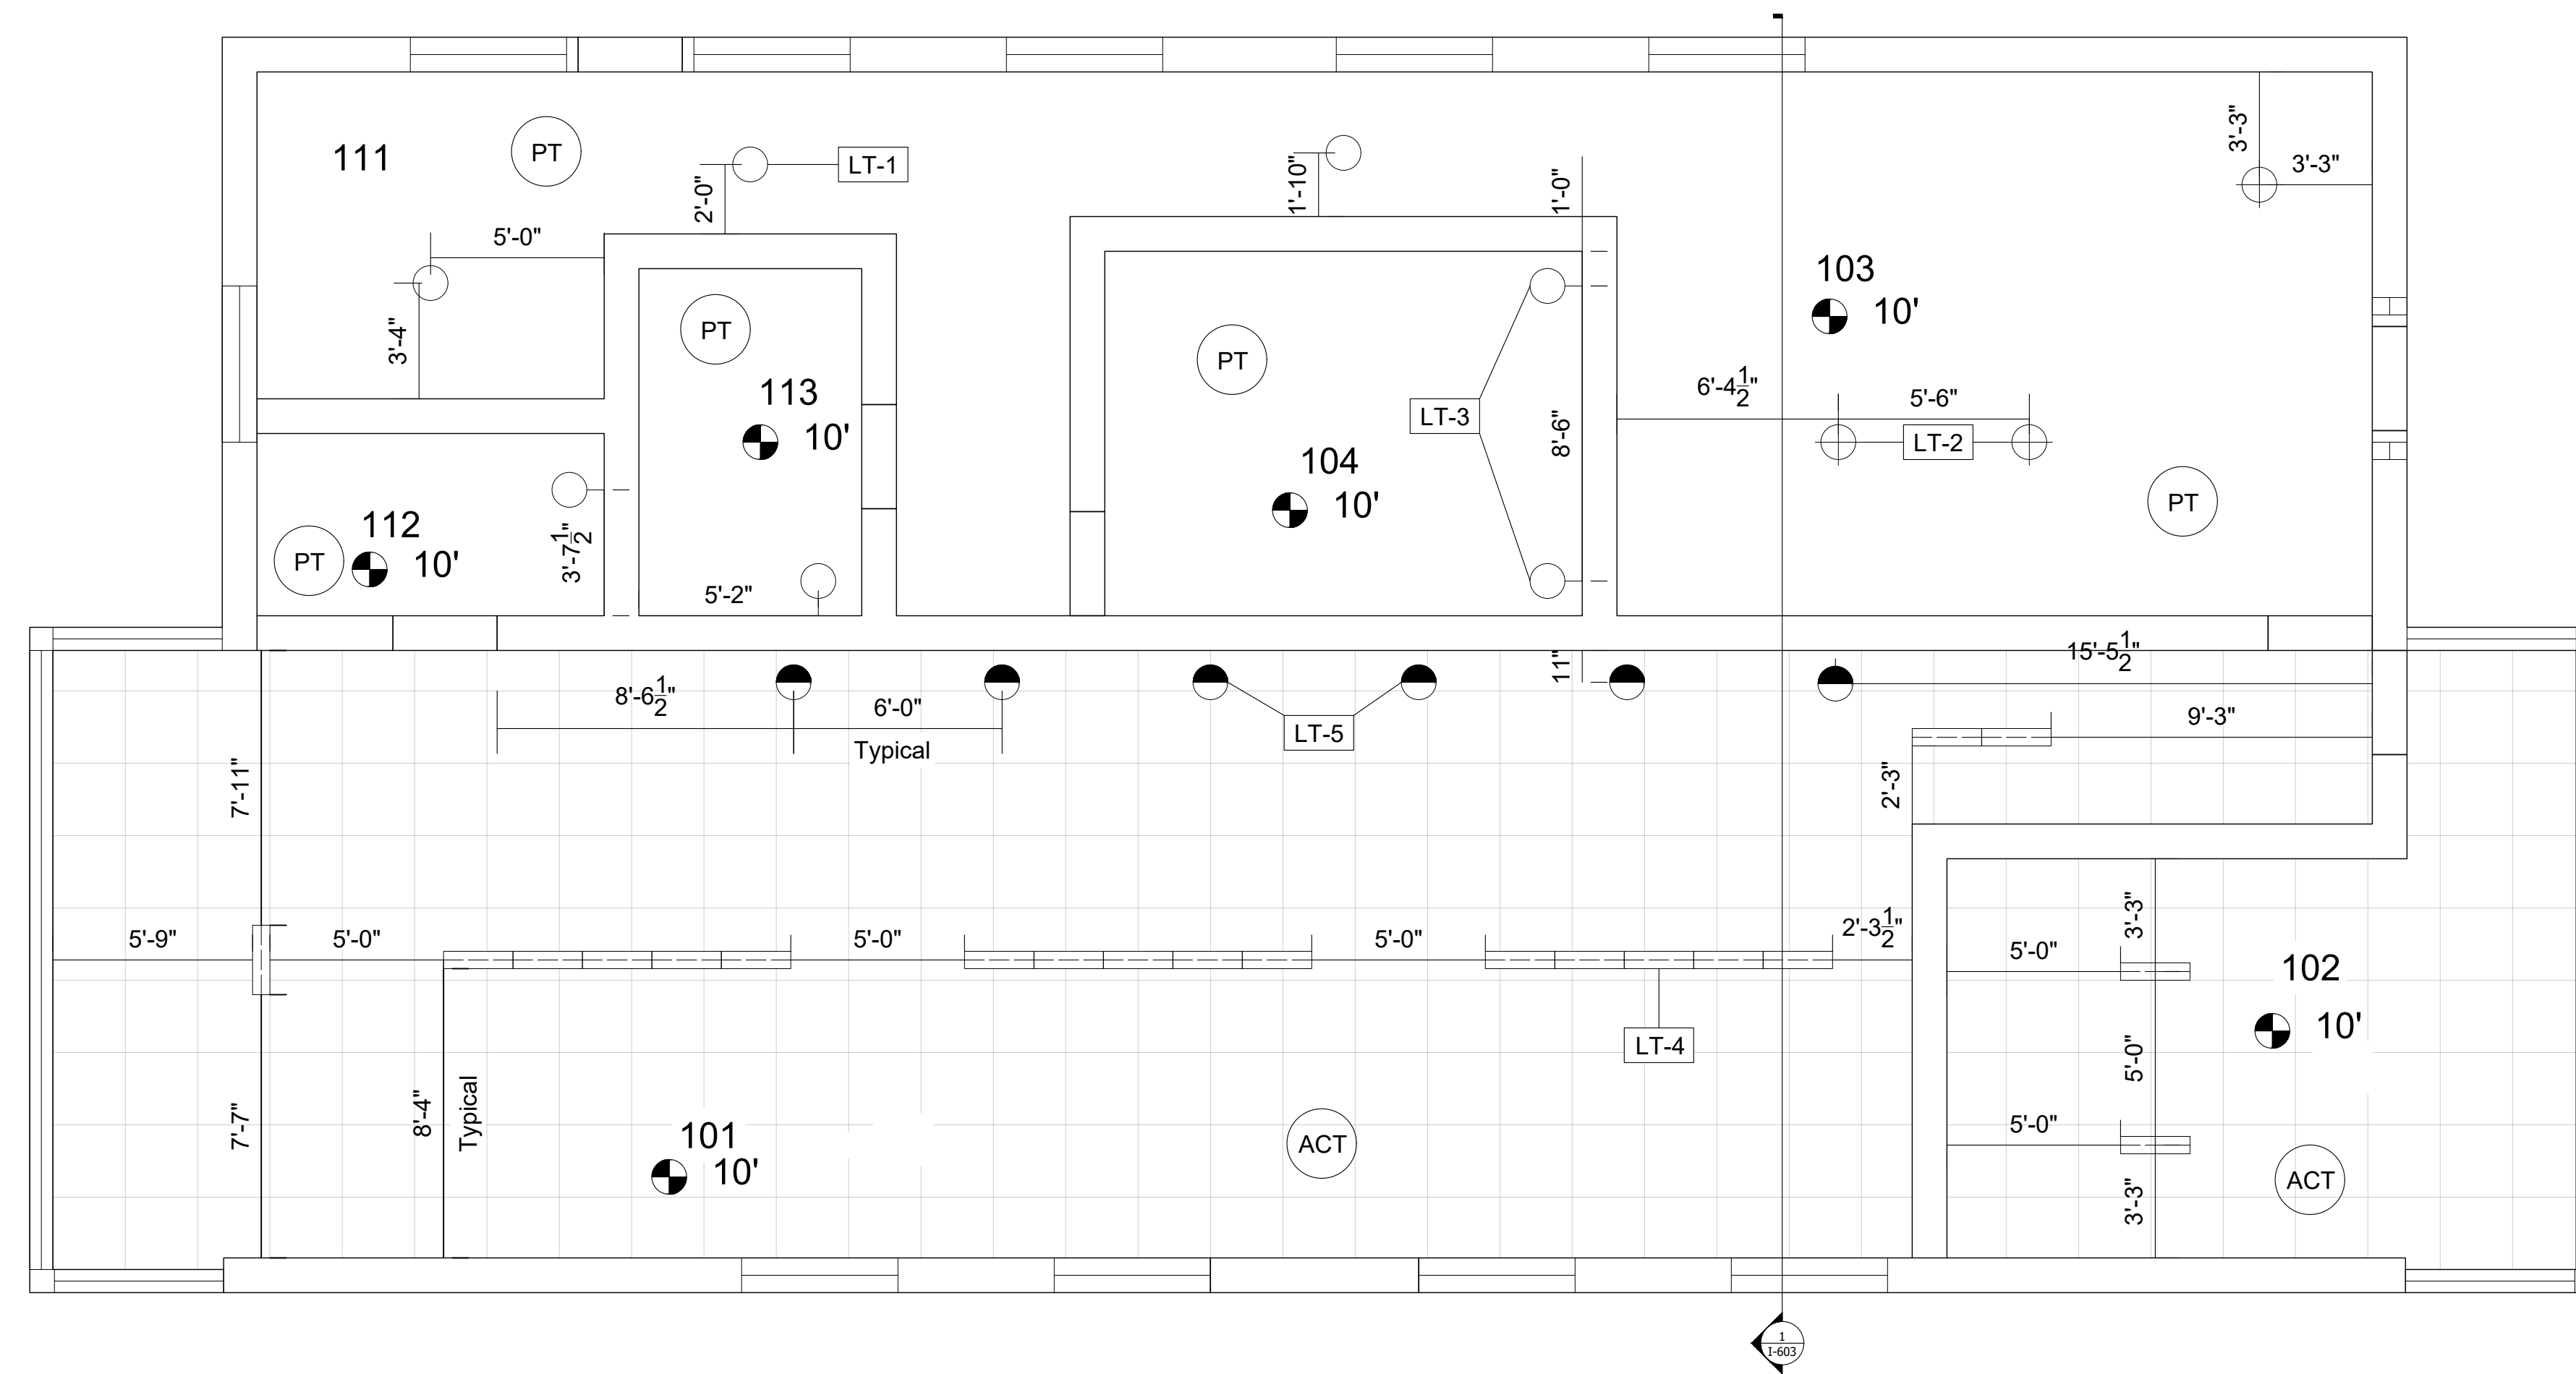

### Ceiling Finish Legend and Schedule

	Acoustic Paneling		10' AFF	Armstrong Ceilings	Sahara White Smooth
	Painted Gypsum		10' AFF	Benjamin Moore	Distant Gray 2124-70

### Light Legend and Schedule


	LT-1	Recessed Down Light		Nime 927	Delta Light	13 Watts	382 Lumens
	LT-2	Warm Pendant Light		Hedra 451 C E27	Delta Light	10 Watts	300 Lumens
	LT-3	Warm Wall Sconce		Gala T 927	Delta Light	11 Watts	643 Lumens
	LT-4	LED Track Light		Streamliner 70S P2483	Delta Light	28 Watts	3157 Lumens
	LT-5	Wall Wash Light		Sneak-R 920	Delta Light	13 Watts	951 Lumens

### Revision

#	By	Date
#001	JM	24/06/2021
#002	JM	01/07/2021
#003	JM	06/07/2021
#004	JM	13/07/2021

### Ceiling Plan

Project Number	#001
Date	24/06/2021
Drawn By	JM
<b>I-301</b>	
1/4"=1'-0"	

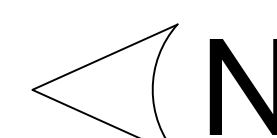




1234 Main Street  
City, US 00001

**Weaver**

00 Somewhere Savannah, GA 00001

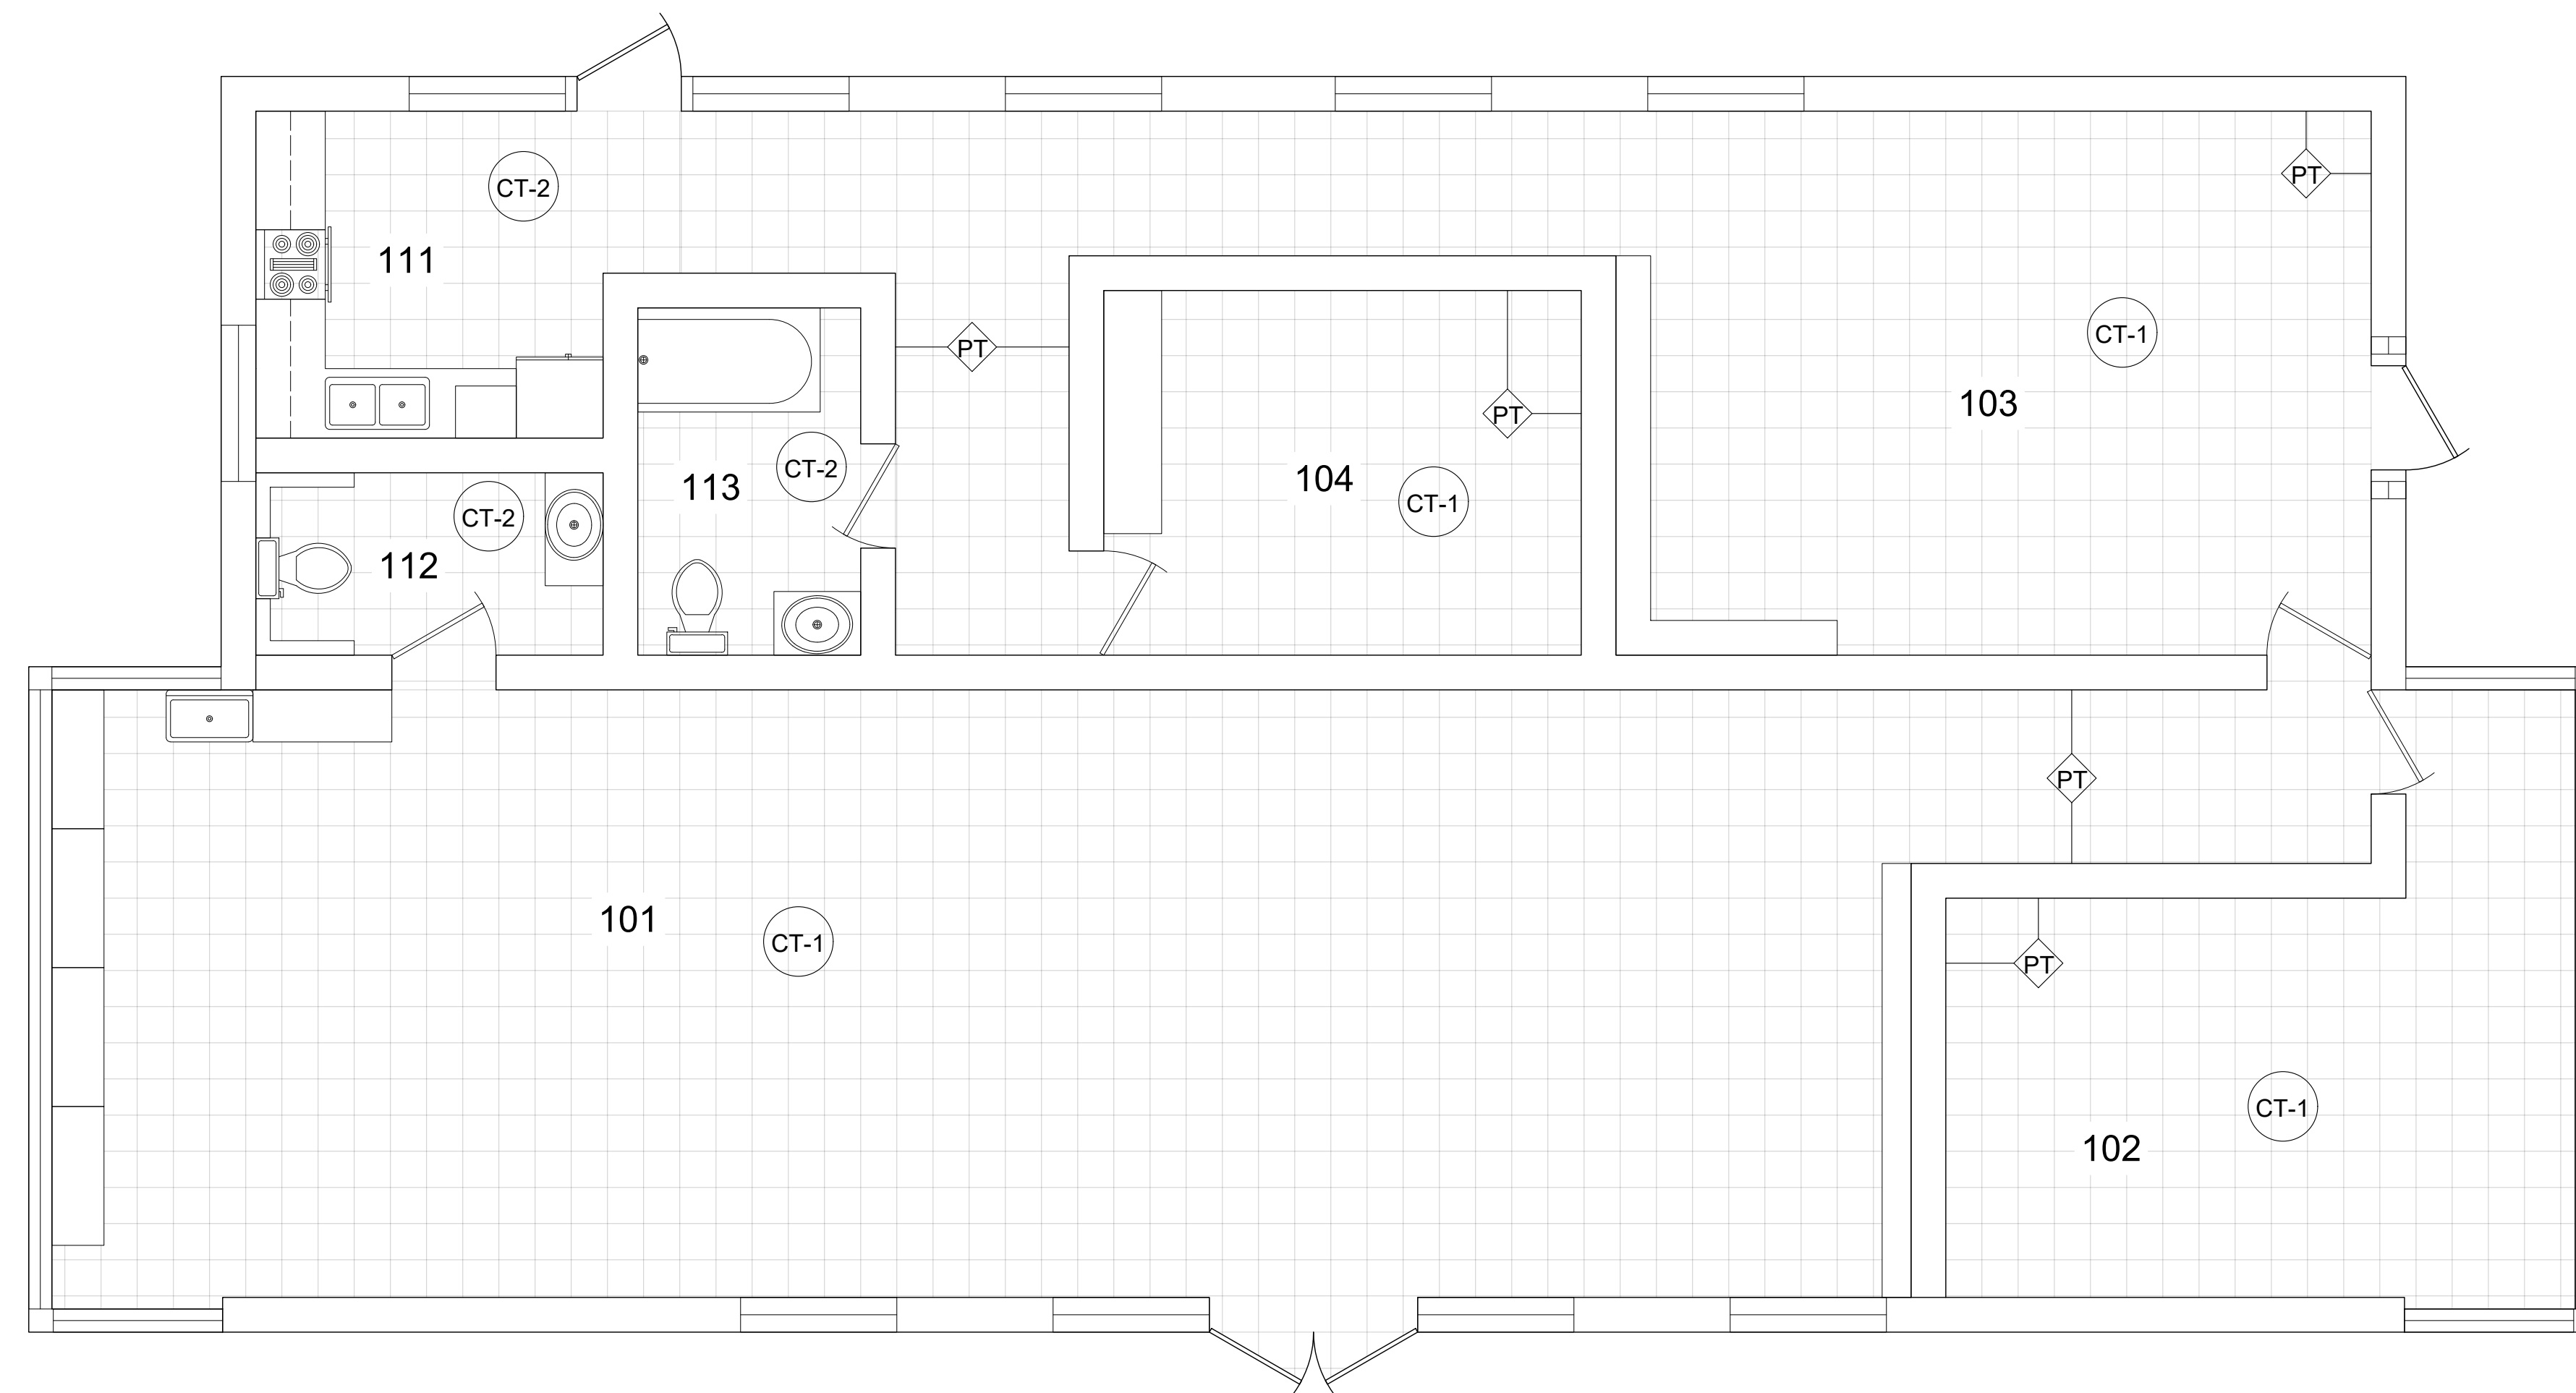

### Legend

<b>CT-1</b>	Access Floor Tile	Tate	Single Piece Porcelain
<b>CT-2</b>	Ceramic Tile	Lifeproof	Carrara Glazed Porcelain
<b>PT</b>	White Paint	Benjamin Moore	Distant Gray 2124-70

### Finish Schedule

Room Number	Room Name	Floor Finish	Ceiling Finish	Wall Finishes
101	Studio	CT-1	ACT	PT
102	Storage	CT-1	ACT	PT
103	Living Room	CT-1	PT	PT
104	Bedroom	CT-1	PT	PT
111	Kitchen	CT-2	PT	PT
112	Studio Restroom	CT-2	PT	PT
113	Apartment Bathroom	CT-2	PT	PT

### Revision


#	By	Date
#001	JM	24/06/2021
#002	JM	01/07/2021
#003	JM	06/07/2021
#004	JM	13/07/2021


### Finishes Plan

Project Number	#001
Date	24/06/2021
Drawn By	JM

**I-401**


1/4"=1'-0"

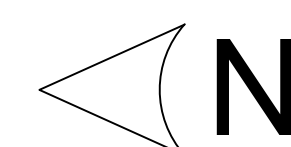

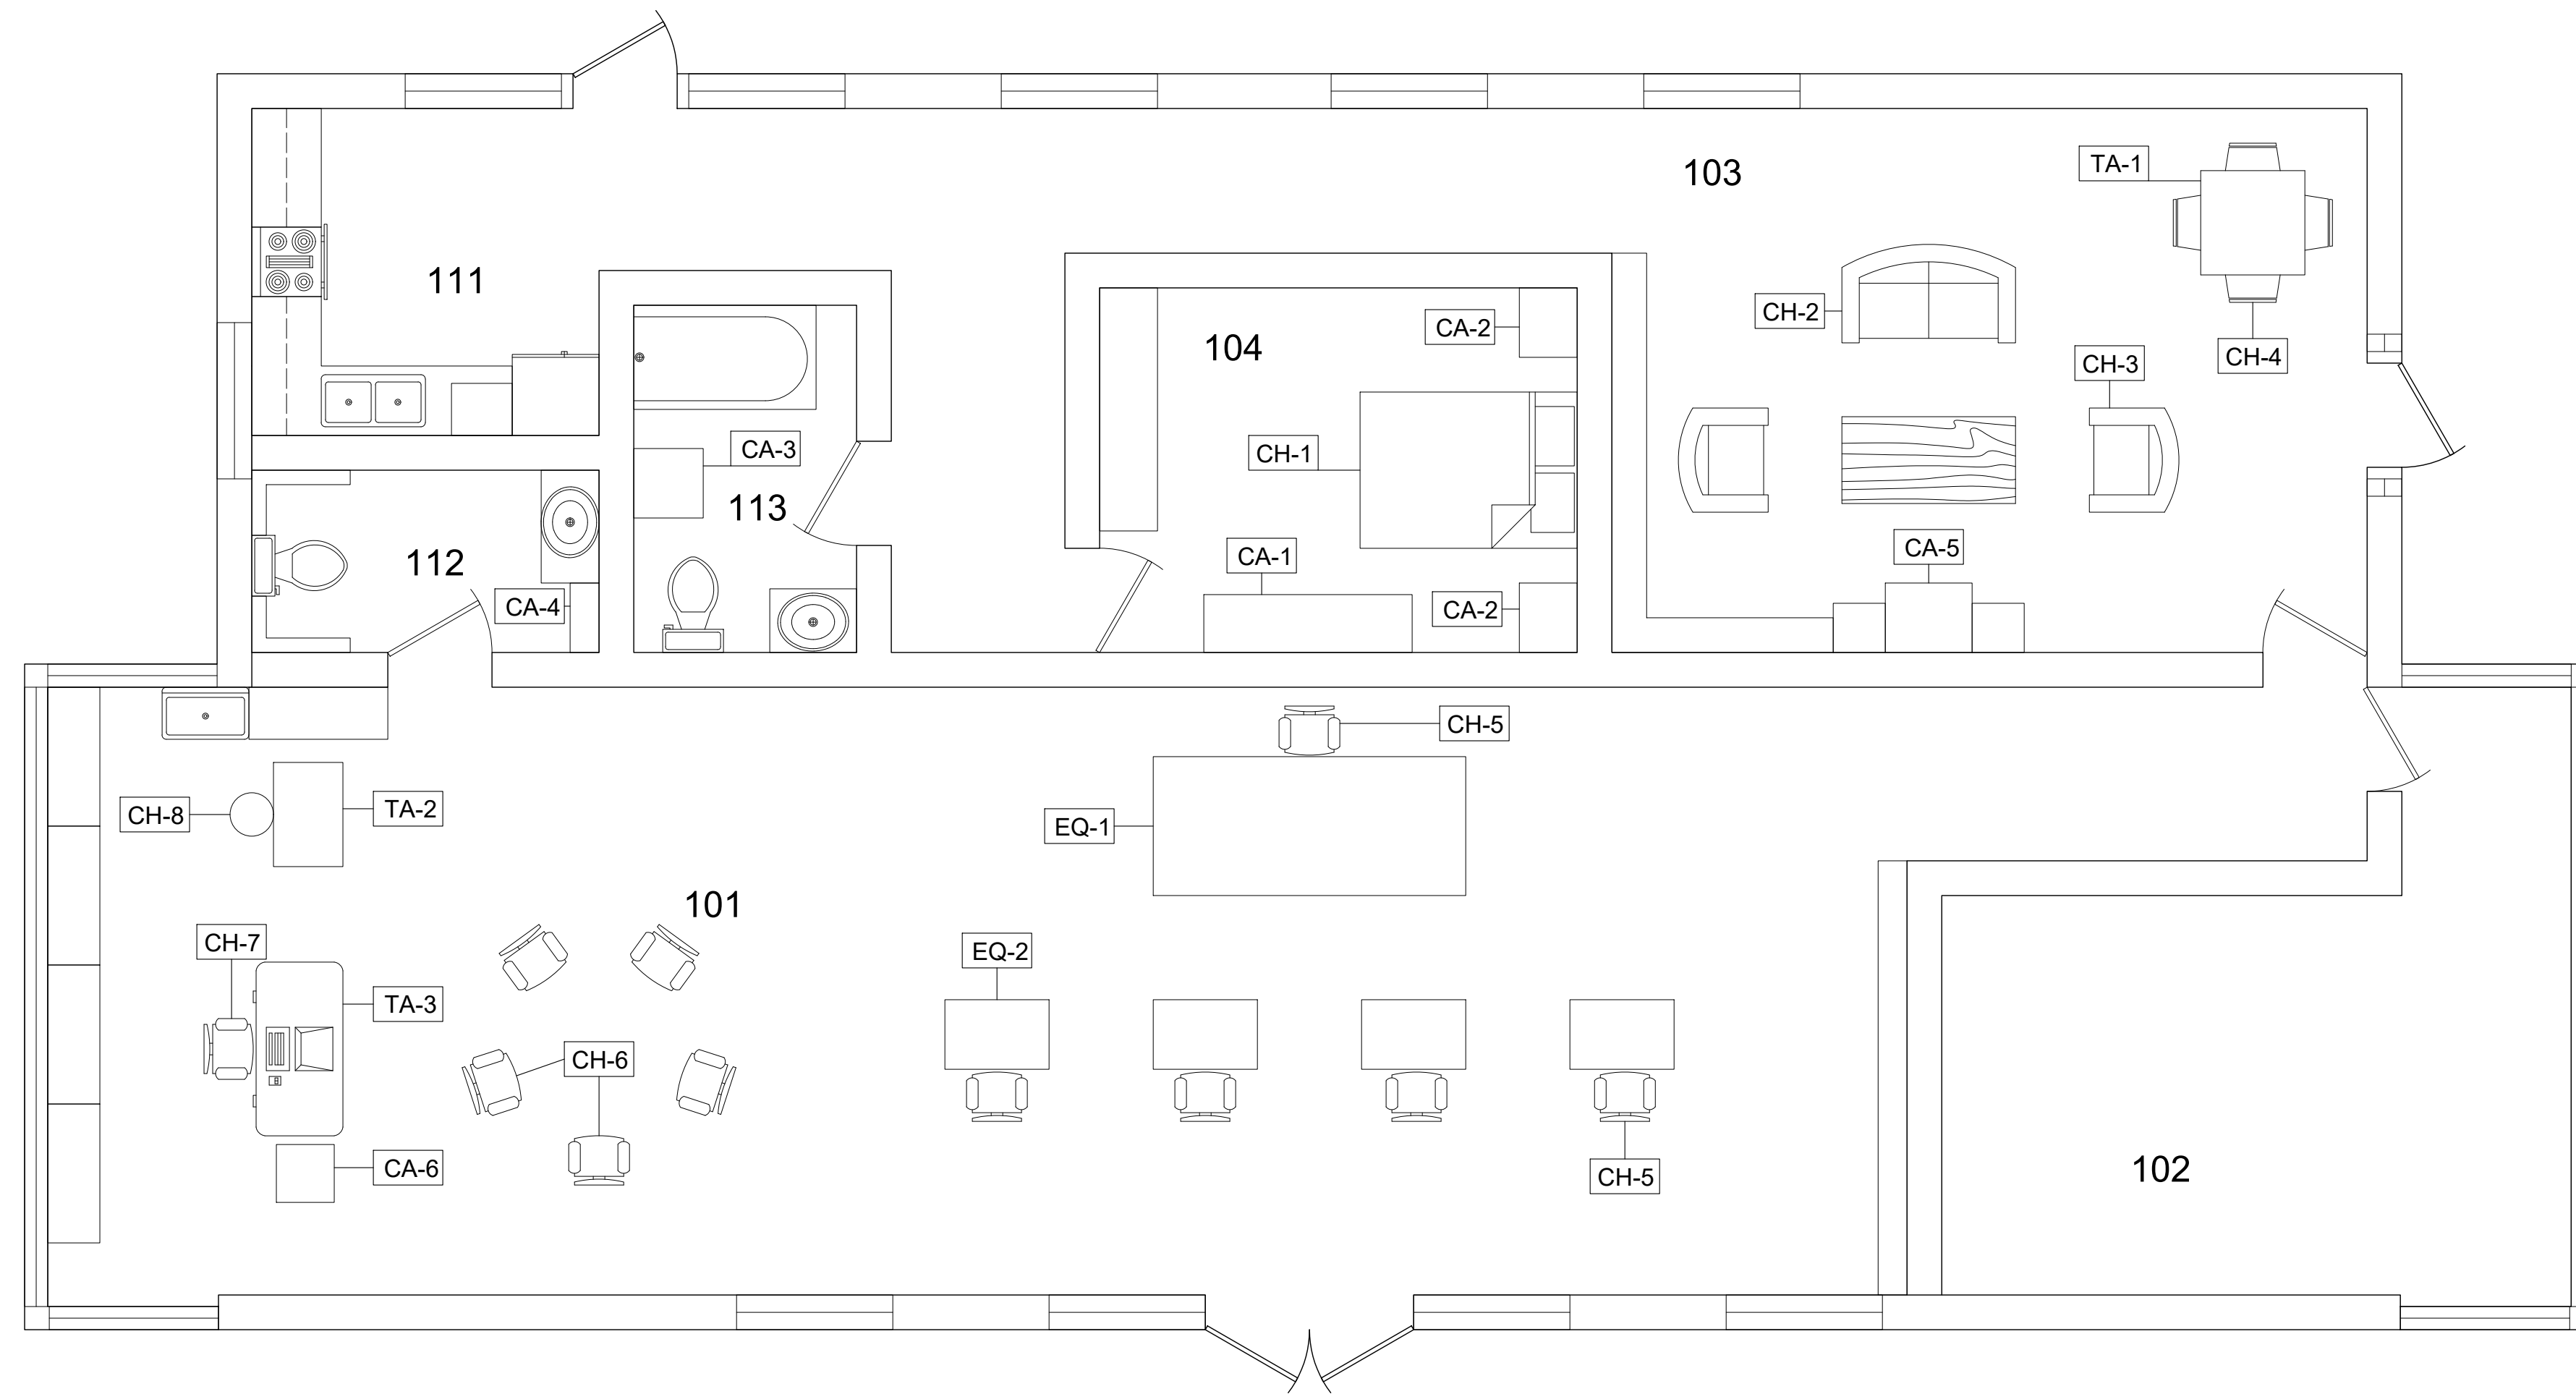

### Legend and Schedule

CH-1	1	Bed frame	Ikea	Malm Luroy Black-Brown	EQ-1	1	Large Weaver Loom	Ikea	N/A
CH-2	1	Sofa	Ikea	Finnala Gunnared Gray	EQ-2	4	Small Weaver Loom	Ikea	N/A
CH-3	2	Armchair	Ikea	Koarp Gunnared Grey	CA-1	1	Dresser	Ikea	Malm Black-Brown
CH-4	4	Dining Chair	Ikea	Volgang Gunnared Gray	CA-2	2	Nightstand	Ikea	Malm Black-Brown
CH-5	5	Work Chair	Ikea	Trollberget Grann Beige	CA-3	1	Bathroom Cabinet	Ikea	Hemnes Gray
CH-6	5	Lounge Chair	Ikea	Pello Holmby Natural	CA-4	1	Bathroom Cabinet	Ikea	Dynan White
CH-7	1	Desk Chair	Ikea	Markus Vissle Dark Gray	CA-5	1	Media Furniture	Ikea	Besta Lappviken Black-Brown
CH-8	1	Stool	Ikea	Dalfred Black	CA-6	1	Drawer Unit	Ikea	Malm Black-Brown

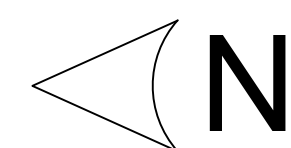

**JM**

1234 Main Street  
City, US 00001

**Weaver**

00 Somewhere Savannah, GA 00001

#### Revision

#001	JM	24/06/2021
#002	JM	01/07/2021
#003	JM	06/07/2021
#004	JM	13/07/2021

### Furniture Plan

Project Number	#001
Date	24/06/2021
Drawn By	JM

**I-501**

1/4"=1'-0"


**JM**

1234 Main Street  
City, US 00001


**Weaver**

00 Somewhere Savannah, GA 00001

**1**

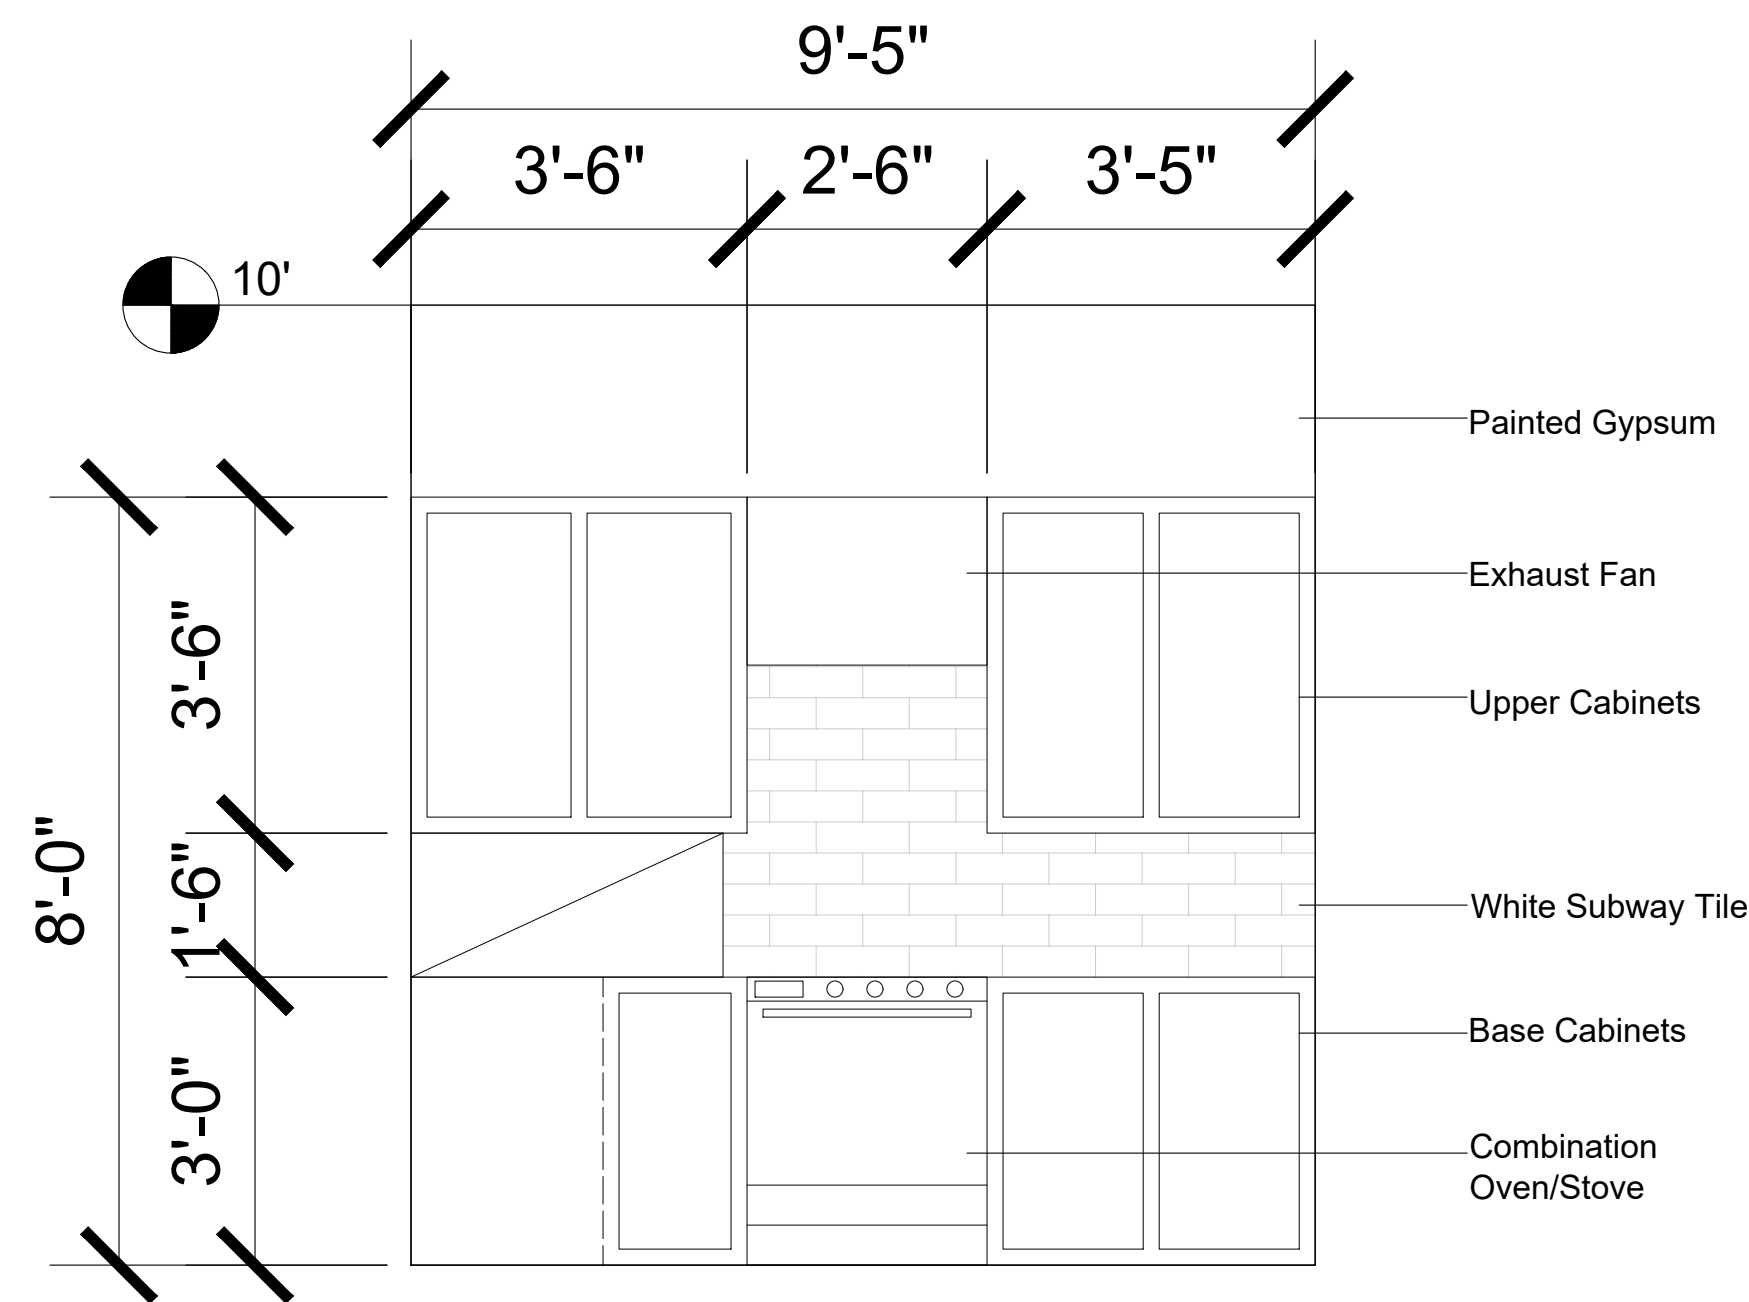

**2**

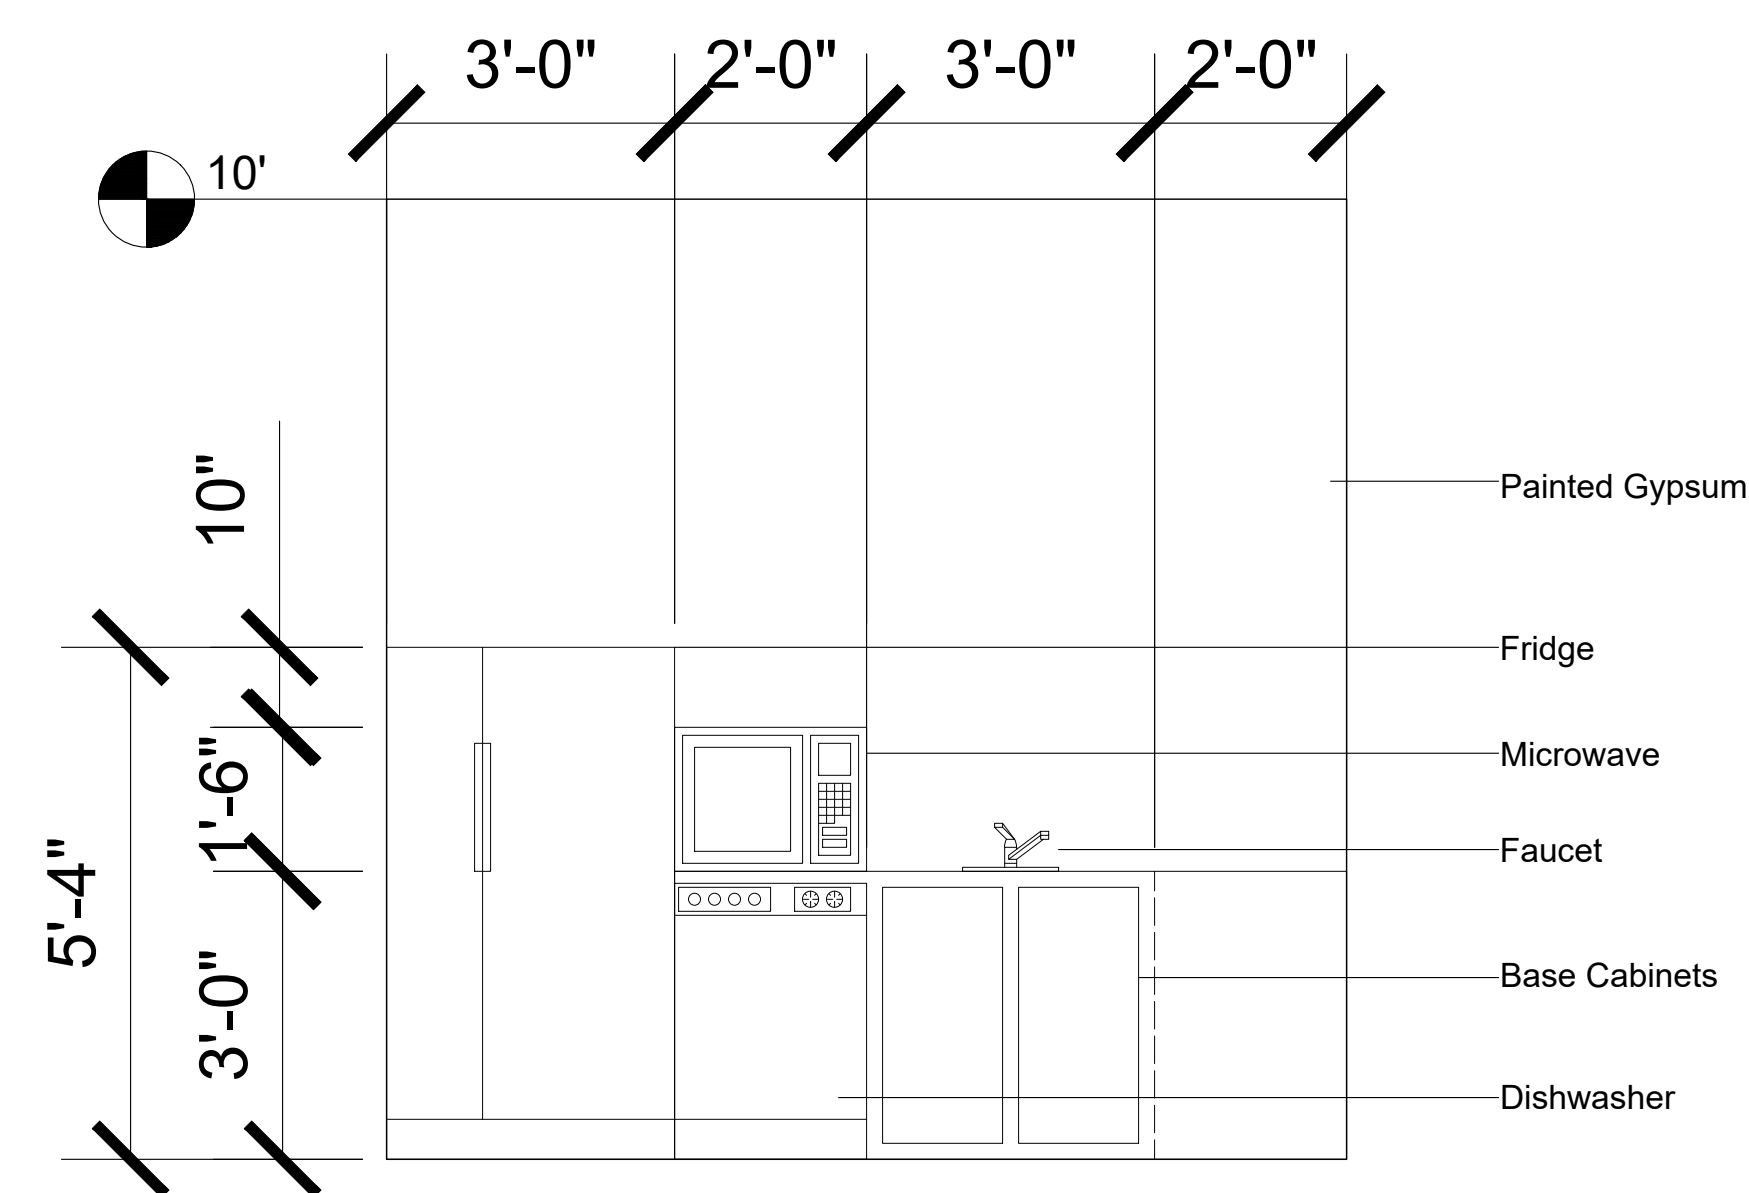


Revision		
#001	JM	24/06/2021
#002	JM	01/07/2021
#003	JM	06/07/2021
#004	JM	13/07/2021


Elevation	
Project Number	#001
Date	24/06/2021
Drawn By	JM
<b>I-601</b>	
$\frac{1}{2}" = 1'-0"$	



1

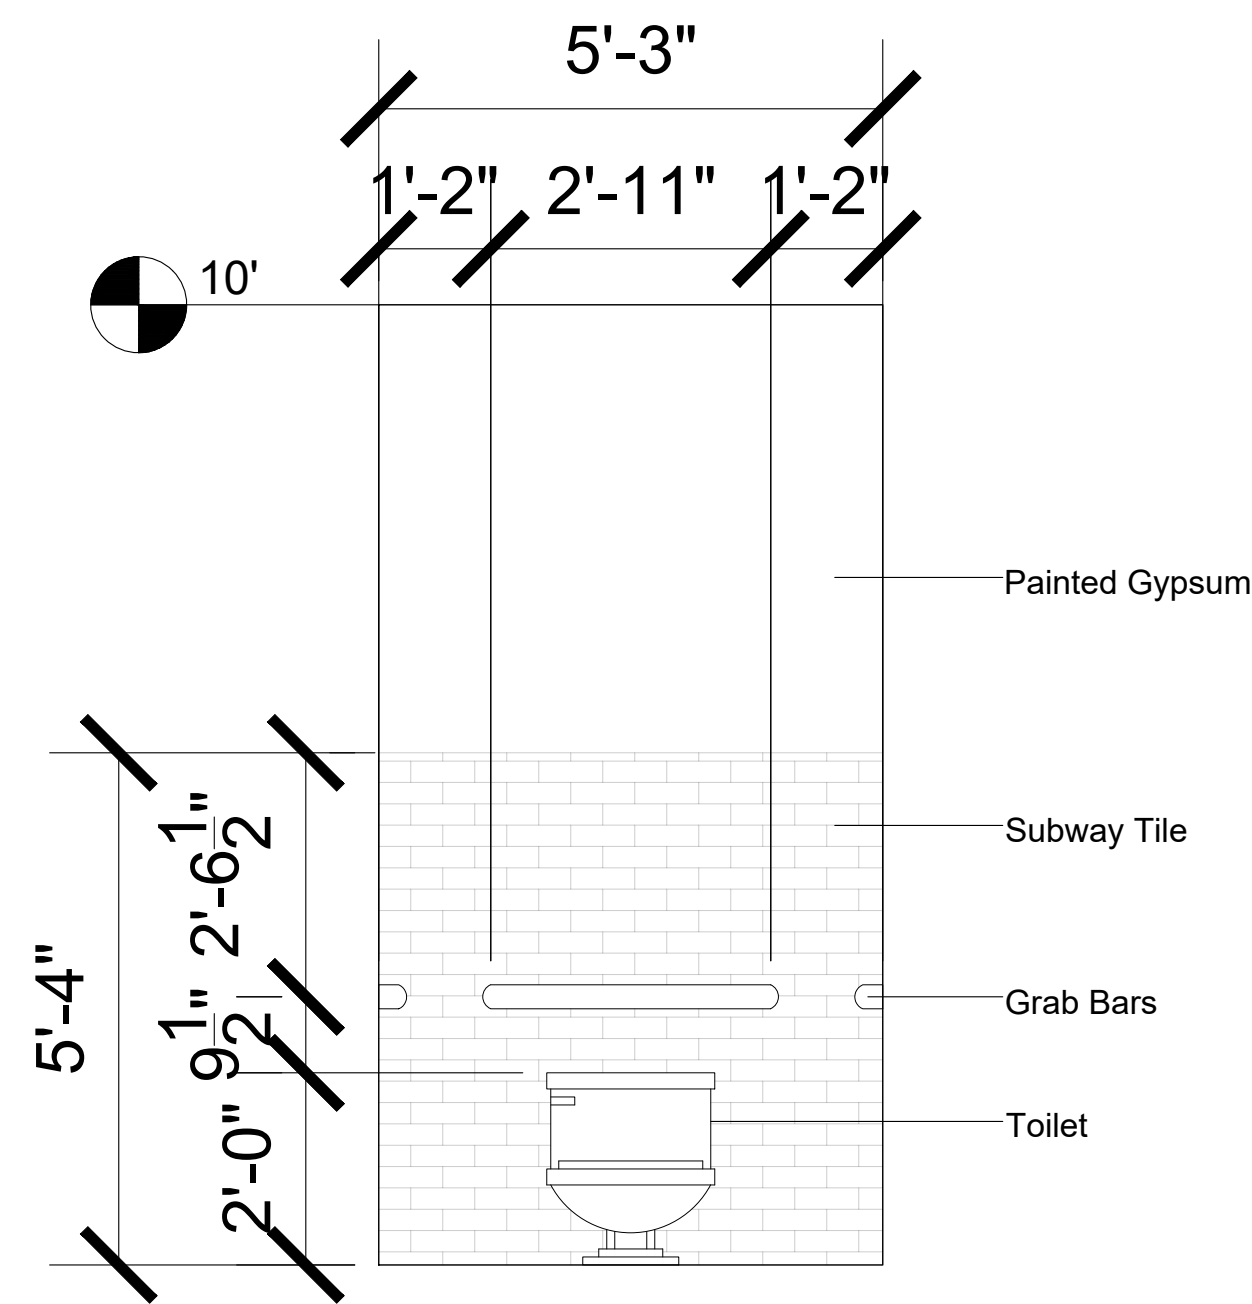

2

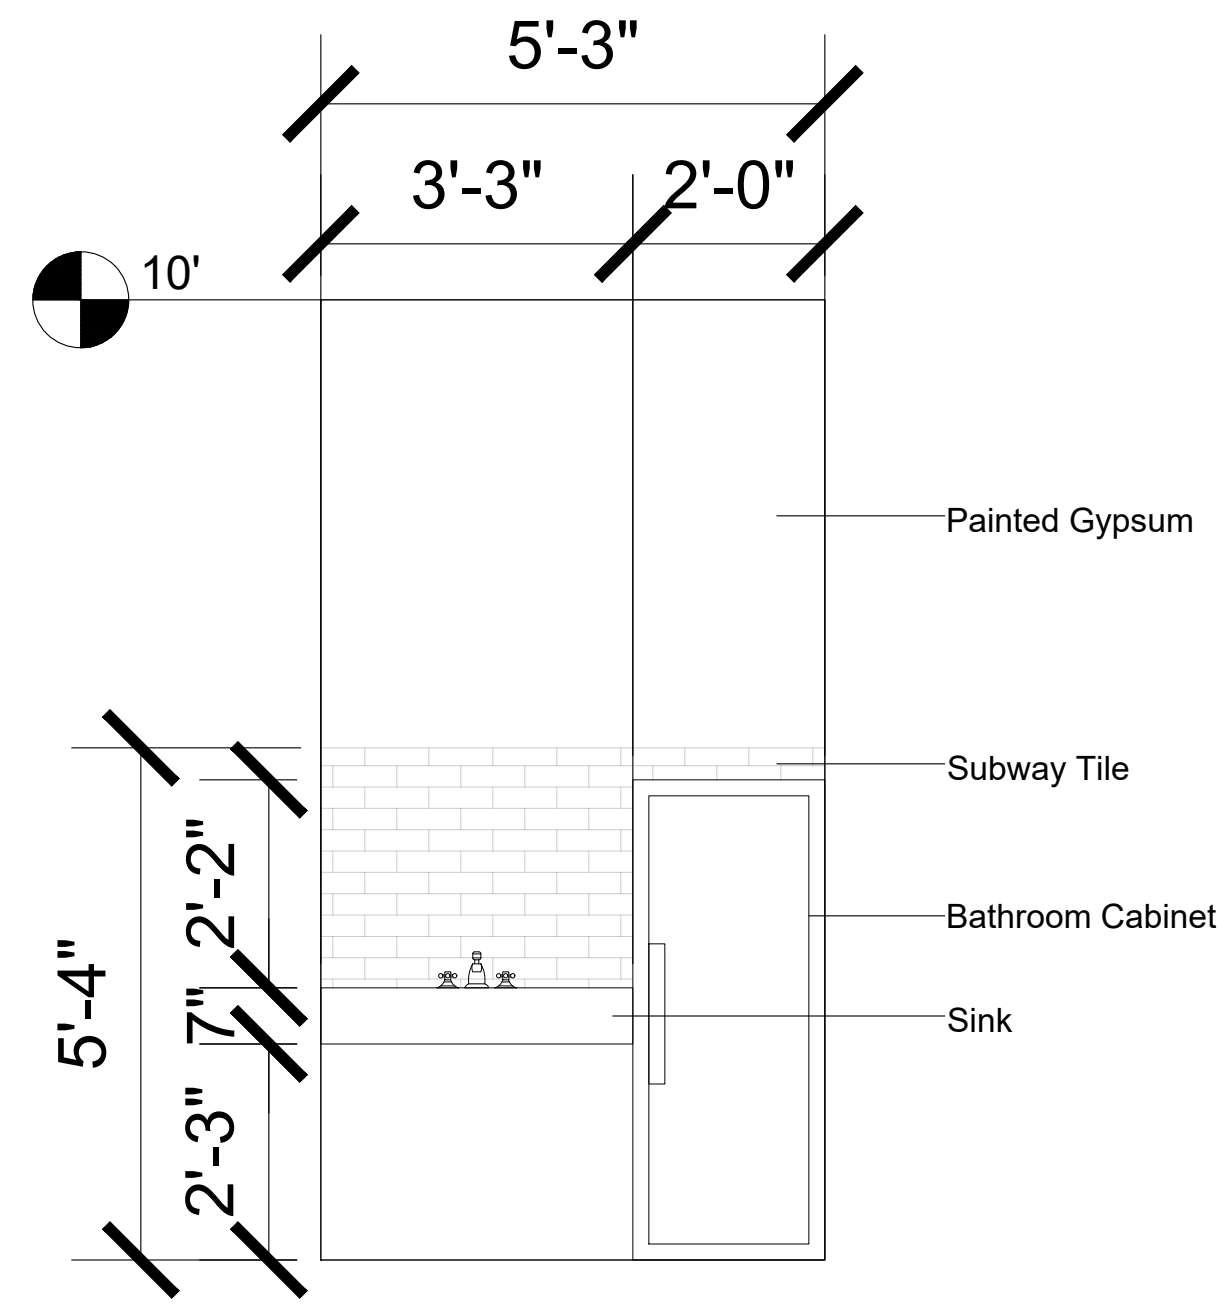


*JM*

1234 Main Street  
City, US 00001

Weaver

 00 Somewhere Savannah, GA 00001



Revision		
#001	JM	24/06/2021
#002	JM	01/07/2021
#003	JM	06/07/2021
#004	JM	13/07/2021


Elevation	
Project Number	#001
Date	24/06/2021
Drawn By	JM
<b>I-602</b>	
$\frac{1}{2}'' = 1'-0''$	

**JM**

1234 Main Street  
City, US 00001

**Weaver**

00 Somewhere Savannah, GA 00001

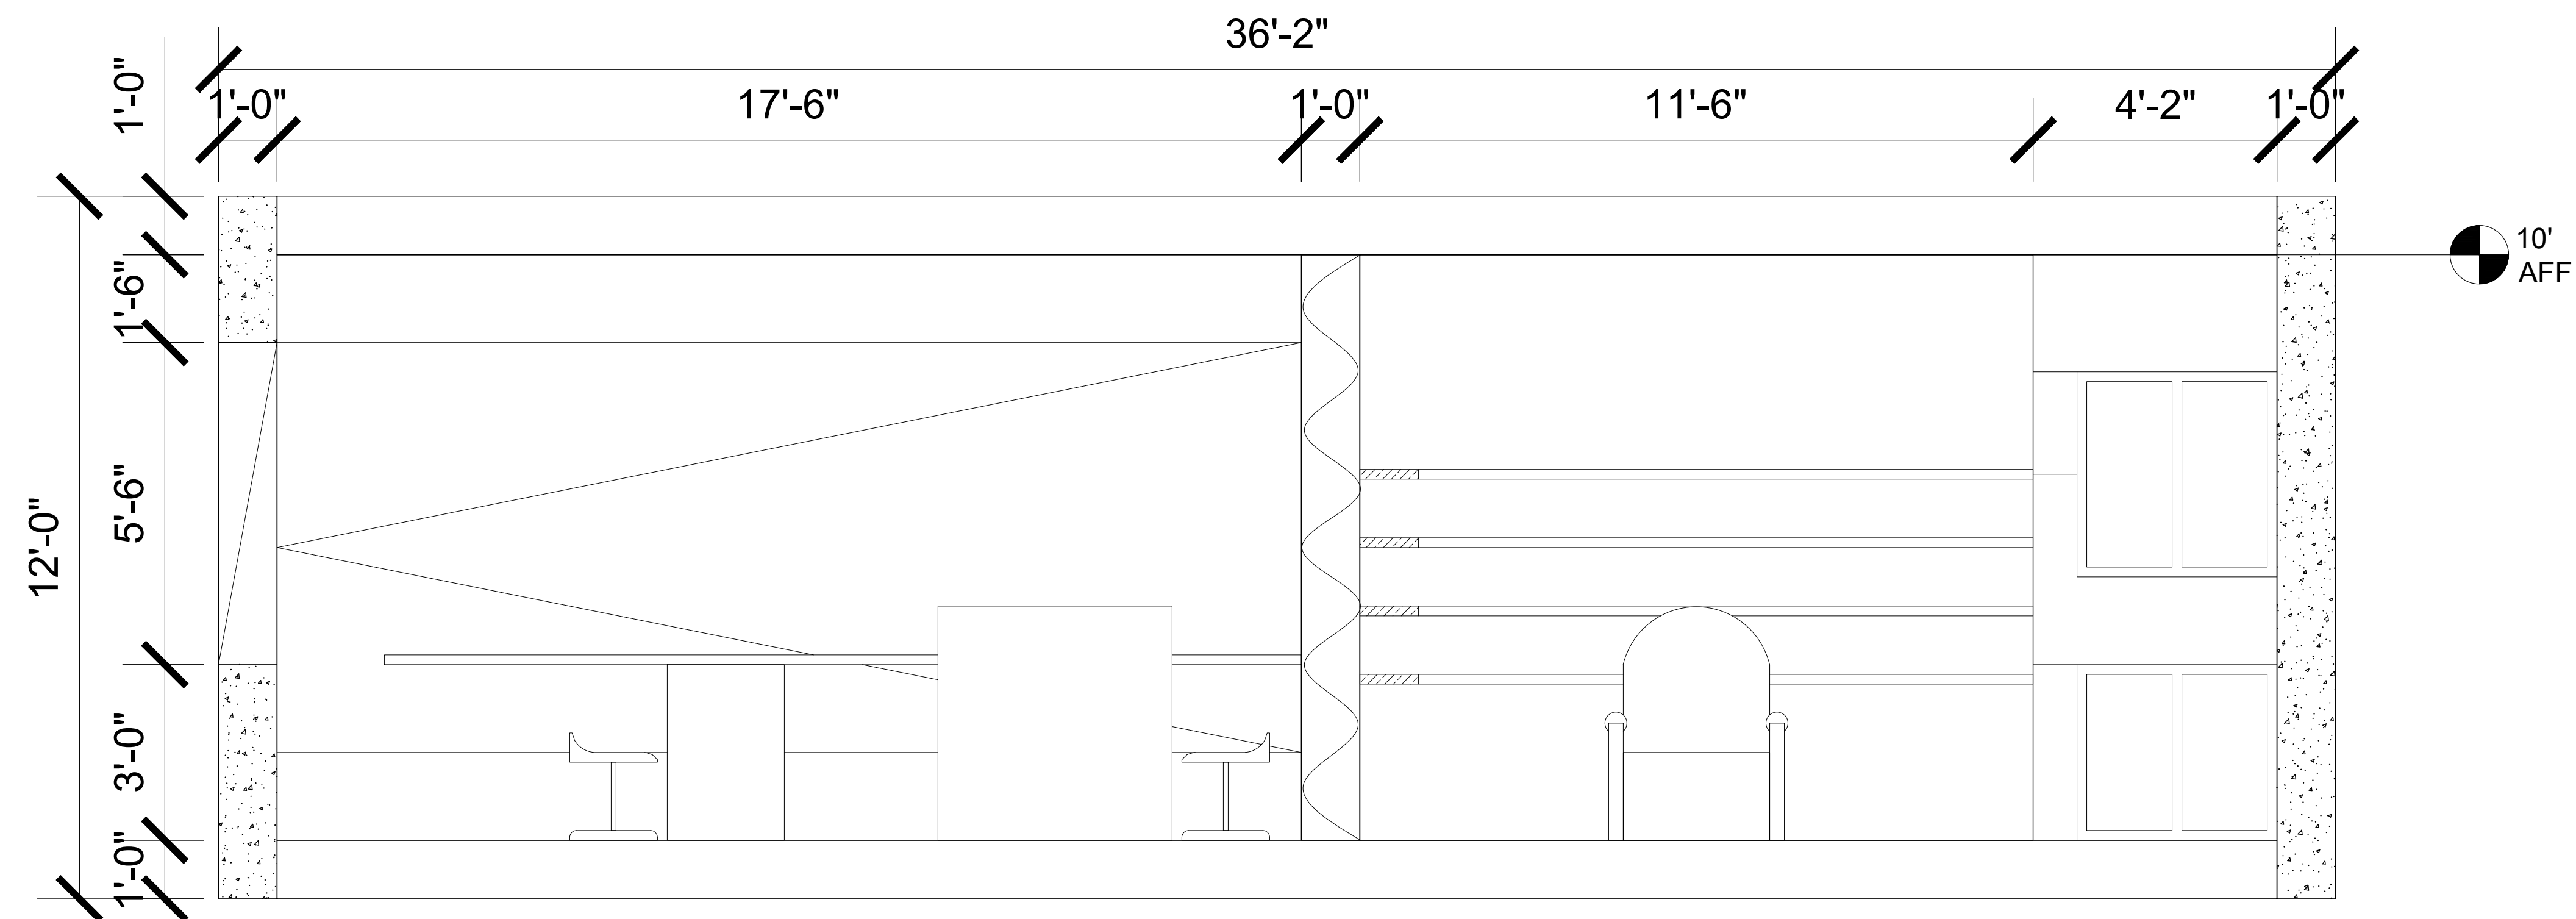

Revision		
#001	JM	24/06/2021
#002	JM	01/07/2021
#003	JM	06/07/2021
#004	JM	13/07/2021

Section	
Project Number	#001
Date	24/06/2021
Drawn By	JM
<b>I-603</b>	
$\frac{1}{2}'' = 1'-0''$	